



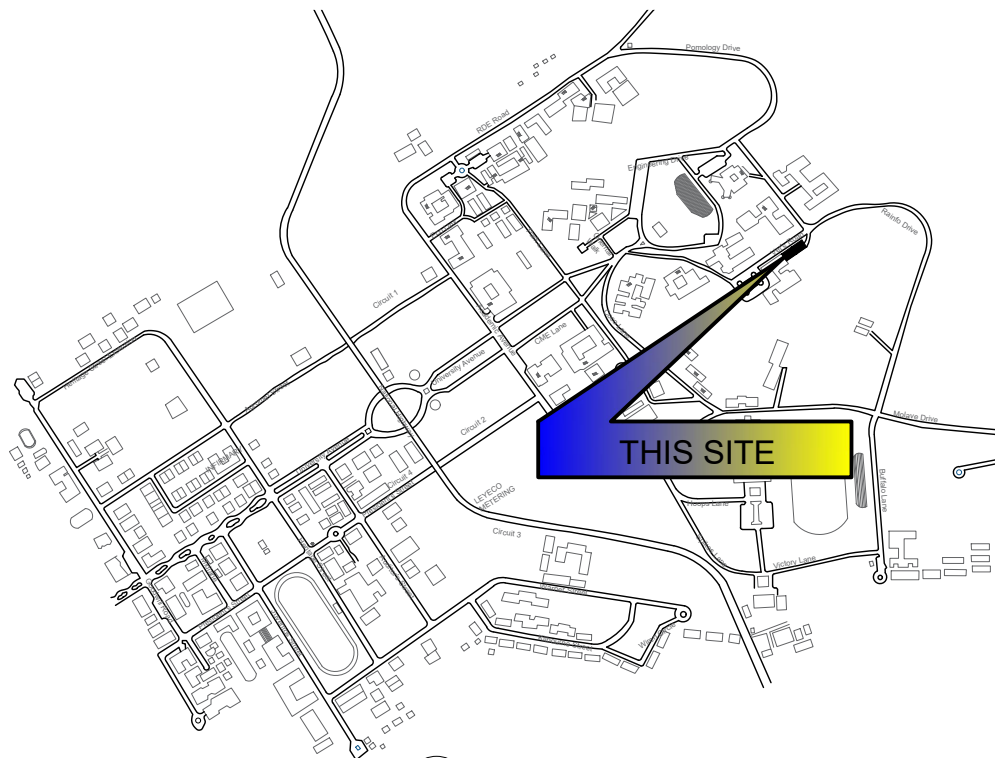

2 VICINITY MAP
Scale: 1:1250

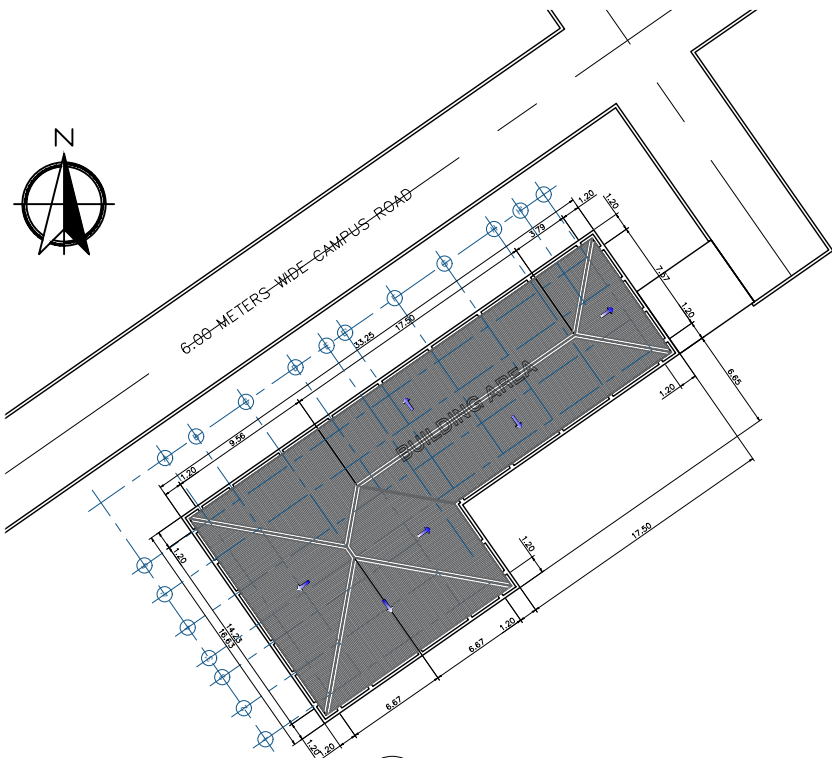

3 SITE DEVELOPMENT PLAN
Scale: 1:500

TABLE OF CONTENTS

Perspective
Vicinity Map
Site Development Plan

First Floor Plan
Second Floor Plan

Front Elevation
Rear Elevation

Right Side Elevation
Left Side Elevation

Longitudinal Section-YY
Cross Sectional-XX

Schedule of Doors
Schedule of Windows

Reflected Ceiling Plan

Foundation Plan

Second Floor Framing Plan

Roof Framing Plan

Roof Plan
Det. of R.C. Roof Beam
Det. of D.S. (Gutter)

Plumbing Layout

Detail of Septic Vault
Plumbing Notes
Legend

Isometric Drawing

Lighting Electrical Layout
Schedule of Load

Convenience Electrical Layout
Electrical Notes
Riser Diagram
Legend

REPUBLIC OF THE PHILIPPINES
DEPARTMENT OF PUBLIC WORKS & HIGHWAYS
OFFICE OF THE BUILDING OFFICIAL
CITY OF BAYBAY

DISTRICT / MUNICIPALITY / CITY

LINE AND GRADE

LAND USE AND ZONING

ARCHITECTURAL

STRUCTURAL

SANITARY

ELECTRICAL

MECHANICAL



TIN :	Approved by :
PRC :	
PTR :	
Date :	
Place :	Architect of Record

THESE DRAWINGS AND SPECIFICATIONS HAVE BEEN PREPARED
EXCLUSIVELY FOR THE PROJECT, AND ARE NOT TO BE USED FOR
ANY OTHER PROJECT. ANY REUSE OF THESE DRAWINGS OR
SPECIFICATIONS WITHOUT THE WRITTEN CONSENT OF THE
ARCHITECT IS STRICTLY PROHIBITED.

Project Title :
CONSTRUCTION OF ANIMAL TESTING FACILITY
Location : VSU Main Campus, Baybay City, Leyte Philippines

Checked by :
Engr. MARIO LLOP. VALENZONA
DIRECTOR, PPO


Noted by :
Dr. SANTIAGO T. PENA, Jr.
DEAN, CVM

Conformed by :
Dr. DANIEL LESLIE S. TAN
VP OF ADMINISTRATIVE AND FINANCE

Approved by :
Dr. EDGARDO E. TULIN
VSU PRESIDENT

Concept by :
AutoCAD by :
Date Started :
Date Finished :
Place :


A7 01
SHEET NO.
01 27

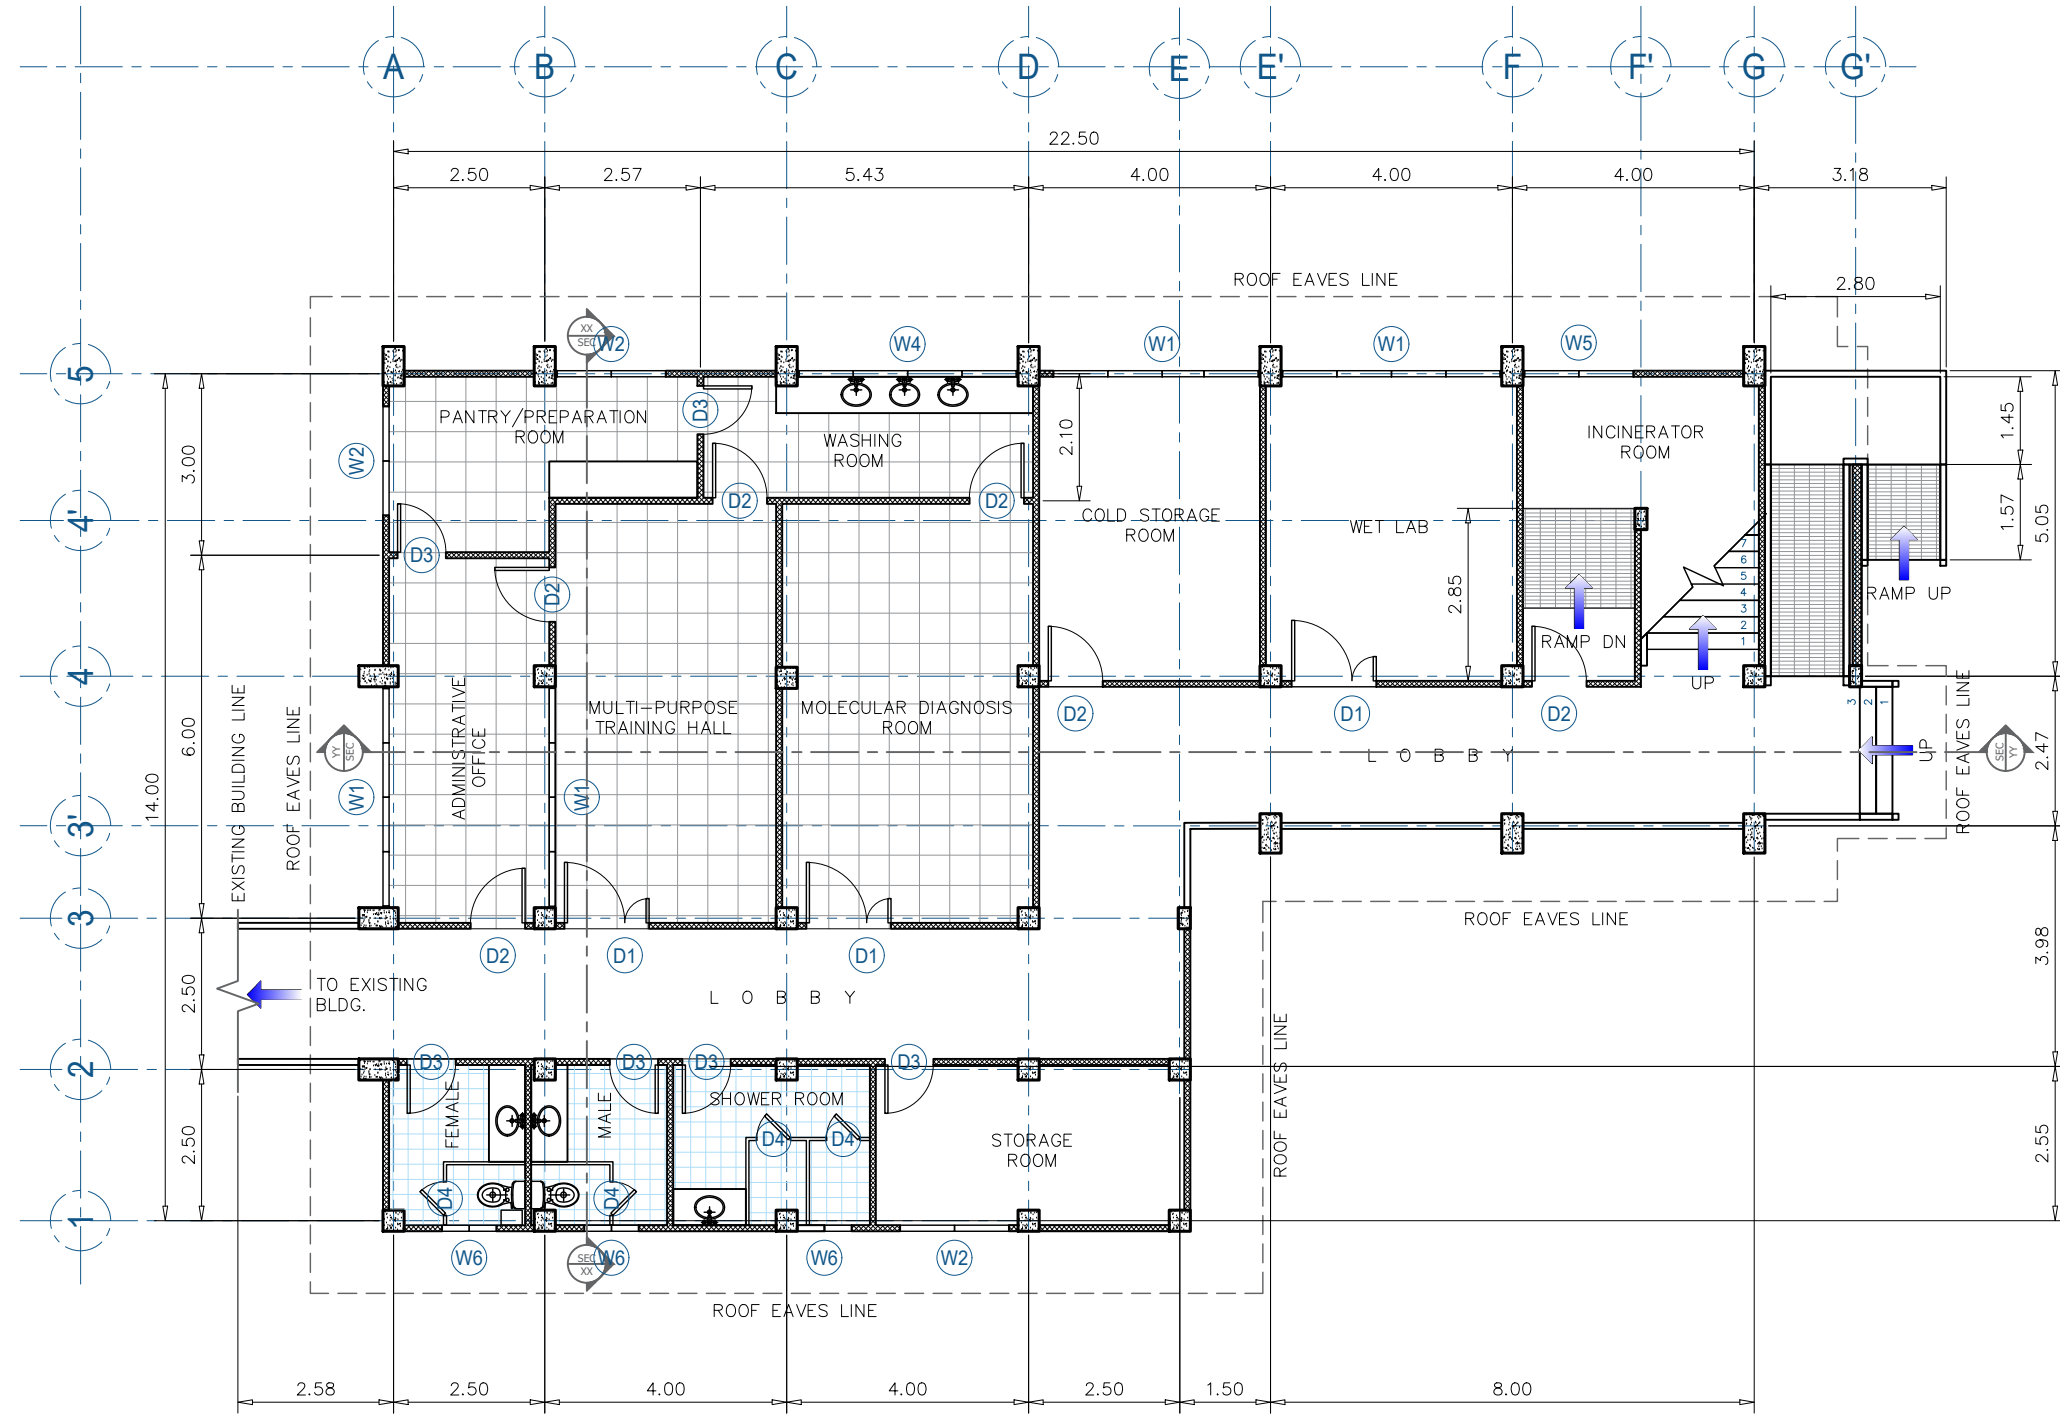

1 FIRST FLOOR PLAN
Scale: 1:125





TIN :	Approved by :	Project Title :	Checked by :	Noted by :	Conformed by :	Approved by :	Concept by :
PRC :		CONSTRUCTION OF ANIMAL TESTING FACILITY	Engr. MARIO LILIO P. VALENZONA	Dr. SANTIAGO T. PENA, Jr.	Dr. DANIEL LESLIE S. TAN	Dr. EDGARDO E. TULIN	A7 02
PTR :		Location : VSU Main Campus, Baybay City, Leyte Philippines	DIRECTOR, PPO	DEAN, CVM	VP OF ADMINISTRATIVE AND FINANCE	VSU PRESIDENT	SHEET NO.
Date :							02 27
Place :	Architect of Record						Place :

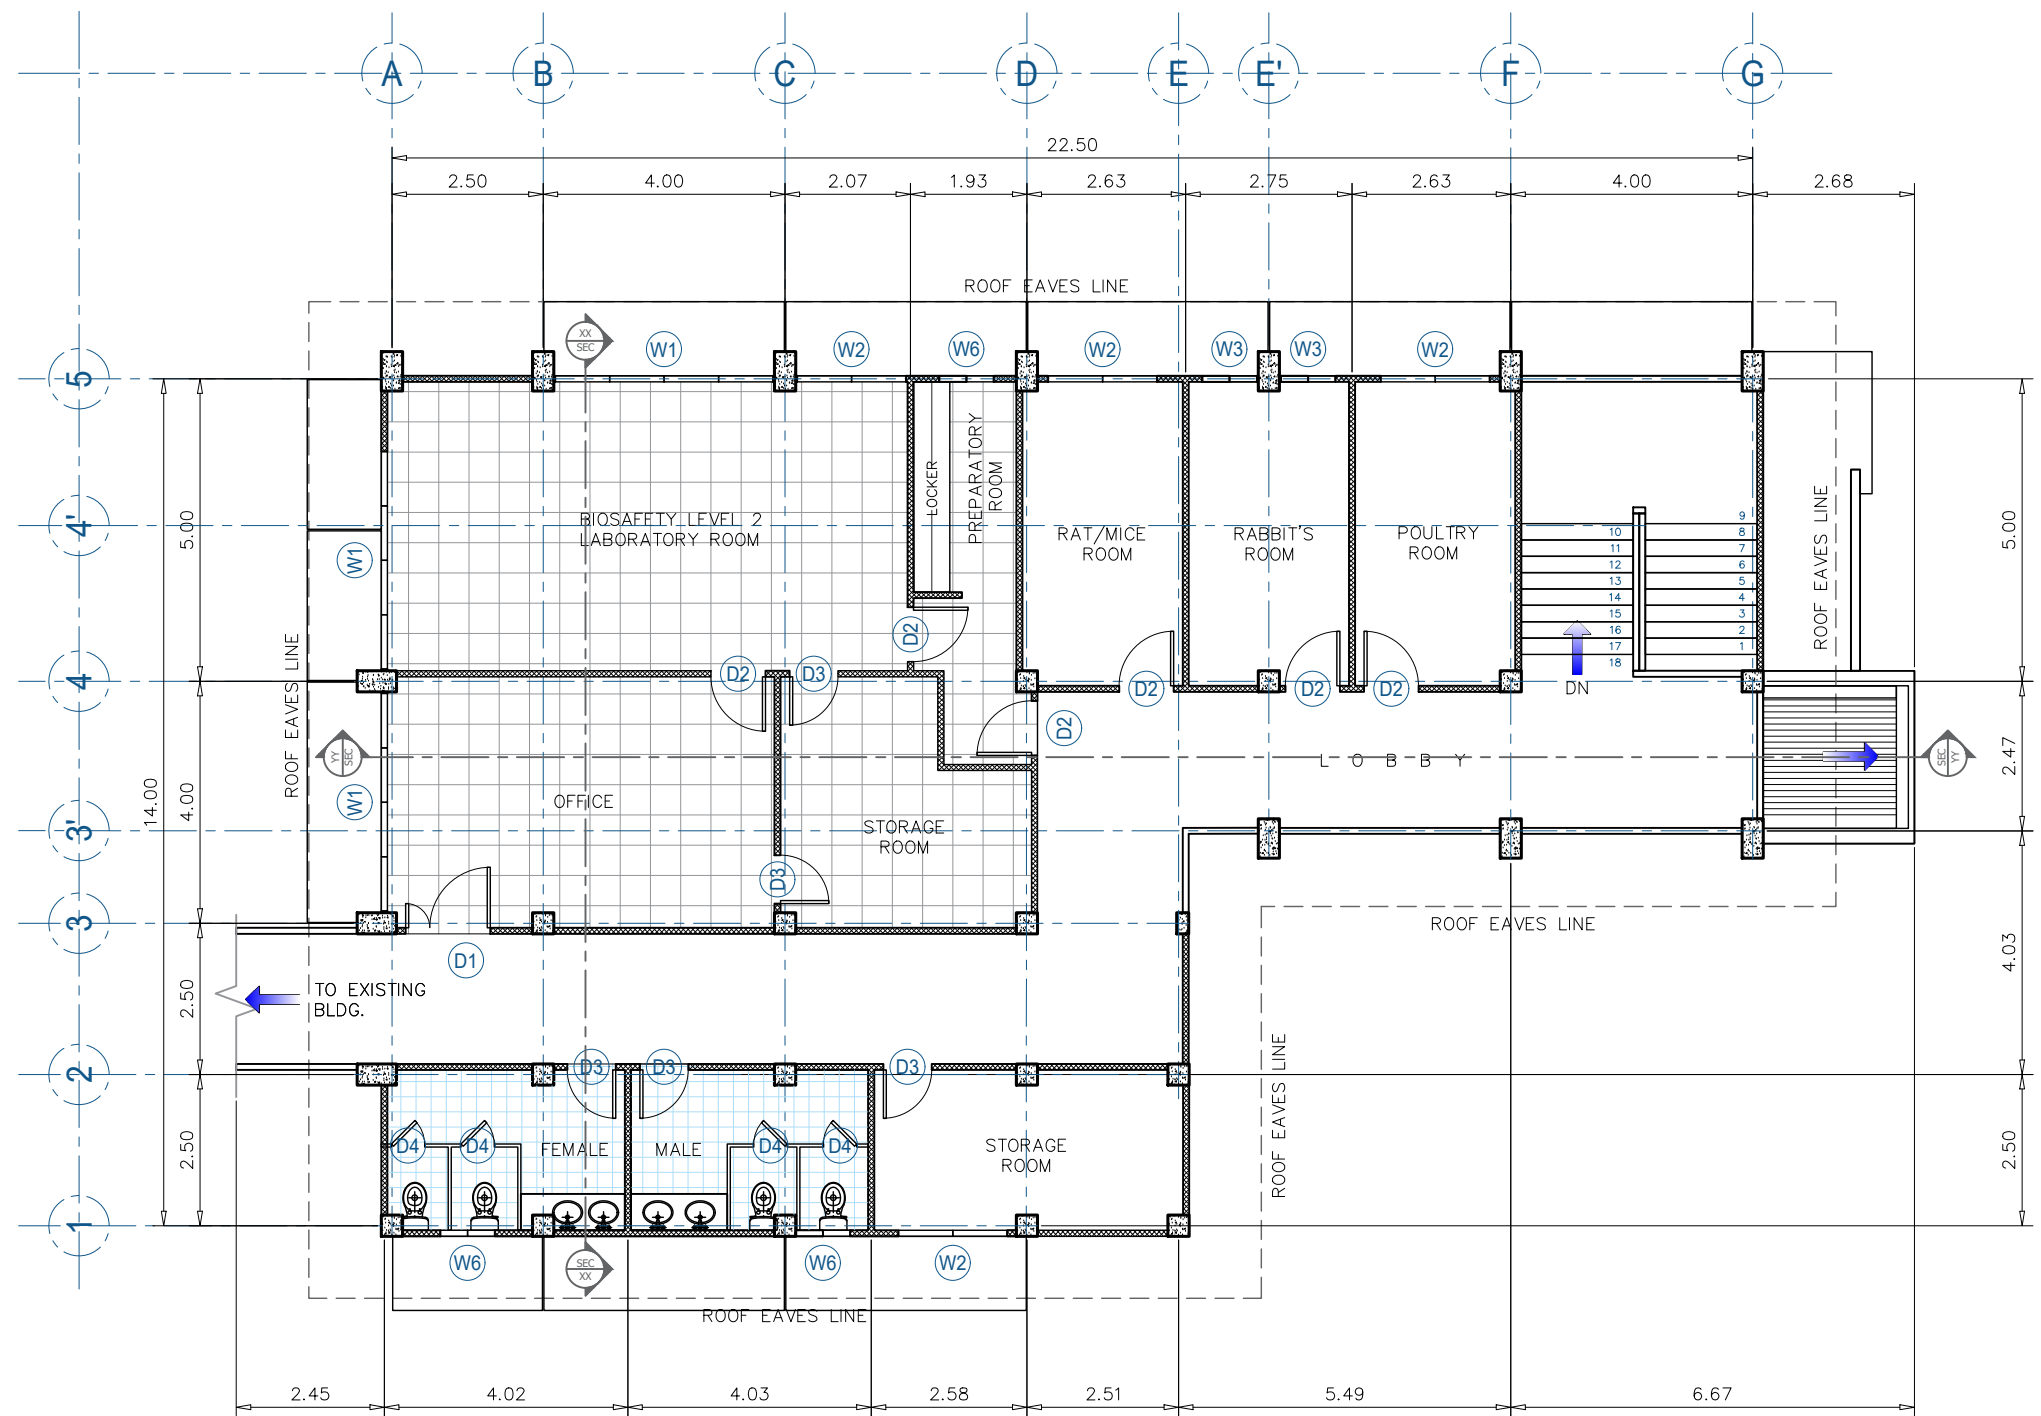



1 SECOND FLOOR PLAN
Scale: 1:125



TIN :	Approved by :	Project Title :	Checked by :	Noted by :	Conformed by :	Approved by :	Concept by :	A7	03
PRC :		CONSTRUCTION OF ANIMAL TESTING FACILITY	Engr. MARIO LILIO P. VALENZONA	Dr. SANTIAGO T. PENA, Jr.	Dr. DANIEL LESLIE S. TAN	Dr. EDGARDO E. TULIN	AutoCAD by :	SHEET NO.	
PTR :		Location : VSU Main Campus, Baybay City, Leyte Philippines	DIRECTOR, PPO	DEAN, CVM	VP OF ADMINISTRATIVE AND FINANCE	VSU PRESIDENT	Date Started :	03	27
Date :							Date Finished :		
Place :	Architect of Record						Place :		

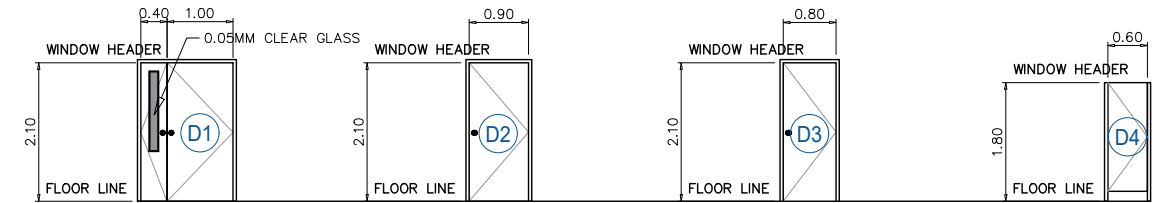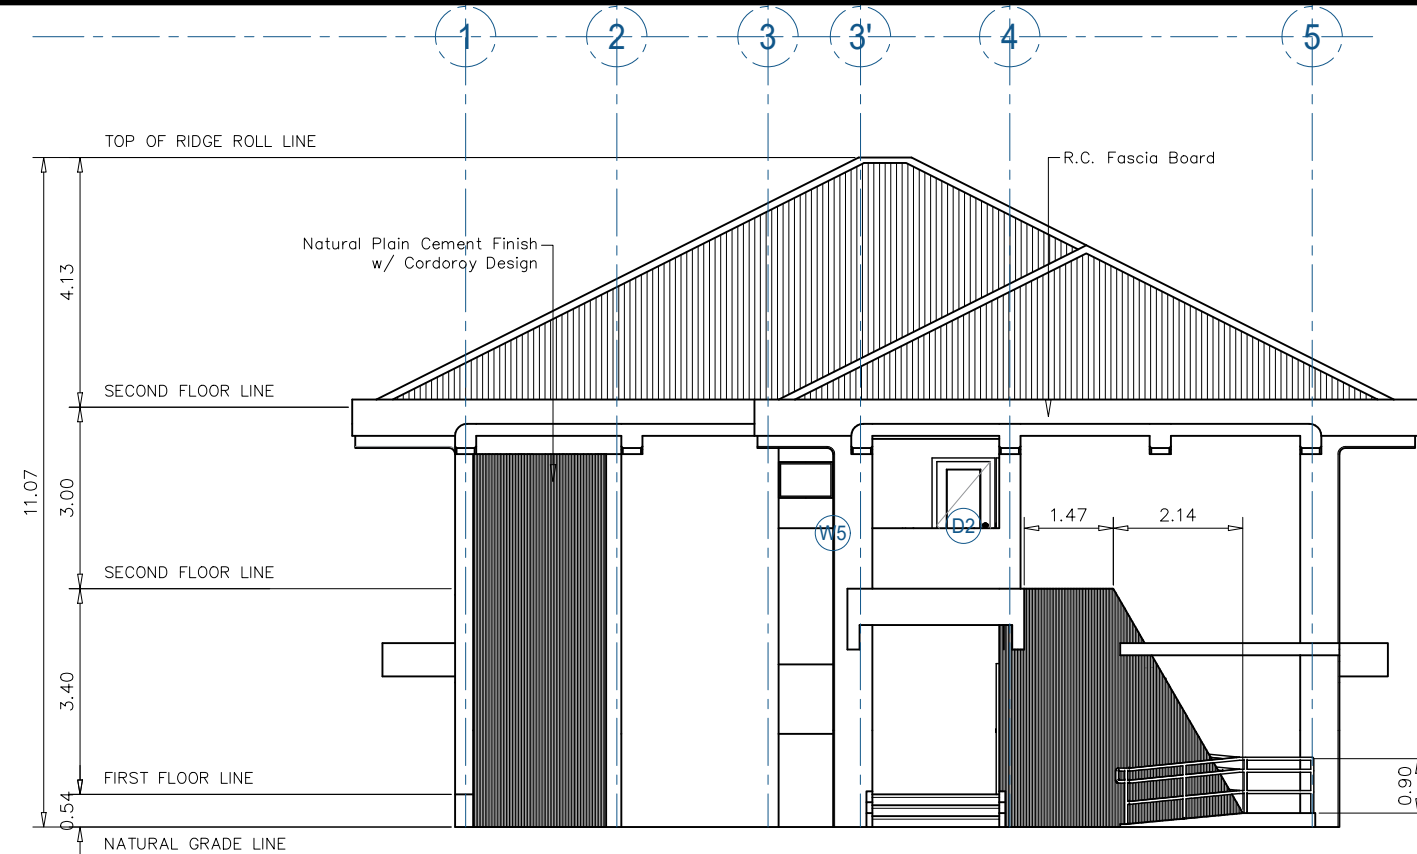

SCHEDULE OF DOORS SCALE : 1:125M.							
NO. OF DOORS	DESIGNATION	HEIGHT	WIDTH	SILL HEIGHT	TRANSOM	NO.OF SET	REMARKS
D1	2 FLUSH DOORS	2.10	1.40	NONE	NONE	4	SWING FLUSH DOOR W/ JAMB AND CLEAR GLASS
D2	1 FLUSH DOOR	2.10	0.90	NONE	NONE	12	SWING FLUSH DOOR W/ WOODEN JAMB
D3	1 FLUSH DOOR	2.10	0.80	NONE	NONE	11	-DO-
D4	1 FLUSH DOOR	1.80	0.60	NONE	NONE	8	-DO-

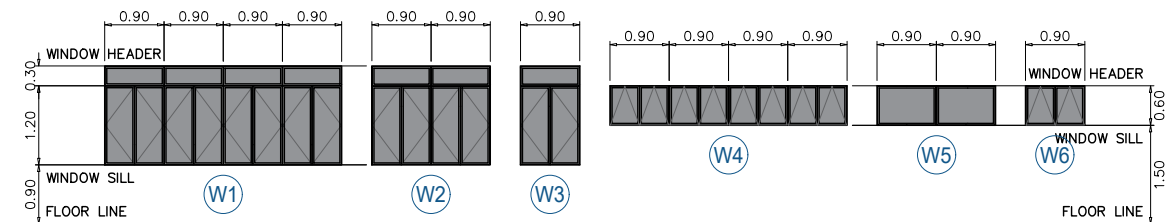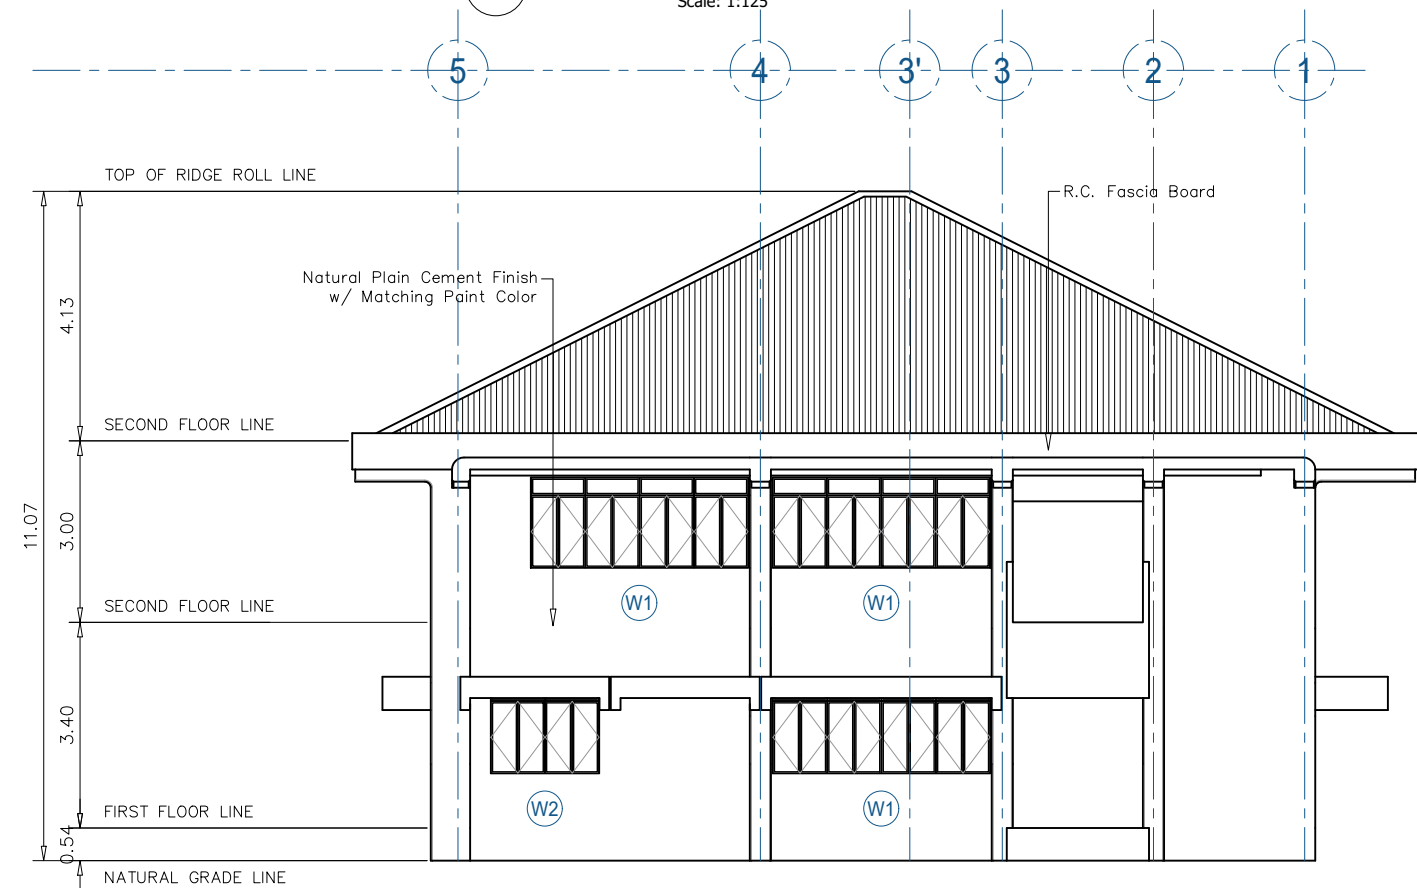

SCHEDULE OF WINDOWS SCALE : 1:125M.							
NO. OF WINDOWS	DESIGNATION	HEIGHT	WIDTH	SILL HEIGHT	TRANSOM	NO.OF SET	REMARKS
W1	4PANEL WINDOW	1.20	3.60	0.90	0.30	6	SWING PANEL AND STEEL CASEMENT FRAME W/ CLEAR GLASS
W2	2PANEL WINDOW	1.20	1.80	0.90	0.30	6	-DO-
W3	1PANEL WINDOW	1.20	0.90	0.90	0.30	2	-DO-
W4	4PANEL WINDOW	0.60	3.60	1.50	NONE	1	-DO-
W5	2PANEL WINDOW	0.60	1.80	1.50	NONE	2	SLIDING PANEL WITH ANALOK FRAME AND CLEAR GLASS
W6	1PANEL WINDOW	0.60	0.60	1.50	NONE	6	SWING PANEL AND STEEL CASEMENT FRAME W/ CLEAR GLASS



TIN:	Approved by:
PRC:	
PTR:	
Date:	
Place:	Architect of Record

01


THIS DRAWING AND SPECIFICATIONS ARE THE PROPERTY OF VISAYAS STATE UNIVERSITY. ANY REPRODUCTION OR USE OF THIS DRAWING WITHOUT THE WRITTEN PERMISSION OF THE ARCHITECT IS STRICTLY PROHIBITED. THE ARCHITECT ASSUMES NO LIABILITY FOR ANY DAMAGE OR LOSS OF ANY KIND, INCLUDING BUT NOT LIMITED TO, THE LOSS OF ANY DATA OR INFORMATION, ARISING FROM THE USE OF THIS DRAWING.

Project Title:	Checked by:
CONSTRUCTION OF ANIMAL TESTING FACILITY	Engr. MARIO LILIO P. VALENZONA
Location: VSU Main Campus, Baybay City, Leyte Philippines	DIRECTOR, PPO


Noted by:	Conformed by:
Dr. SANTIAGO T. PENA, Jr.	Dr. DANIEL LESLIE S. TAN
DEAN, CVM	VP OF ADMINISTRATIVE AND FINANCE

Approved by:	Concept by:
Dr. EDGARDO E. TULIN	AutoCAD by:
VSU PRESIDENT	Date Started:
	Date Finished:
	Place:

A7 04	SHEET NO.
04 27	

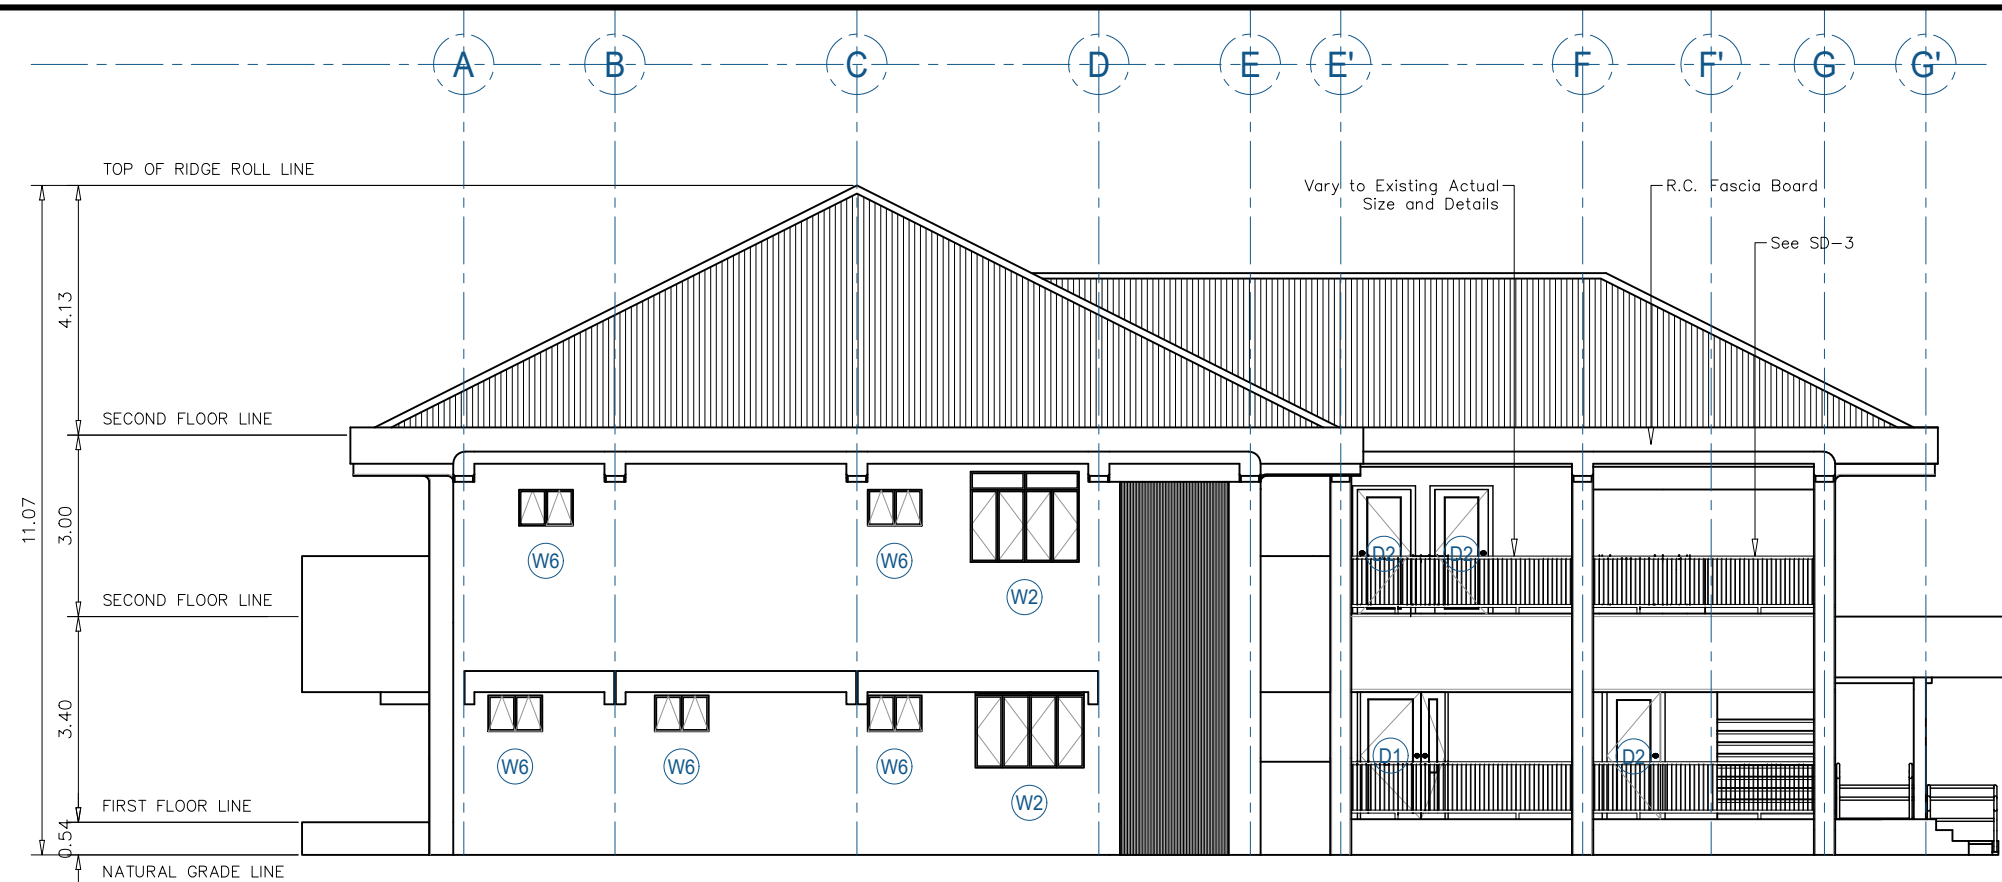




1 RIGHT SIDE ELEVATION
Scale: 1:125

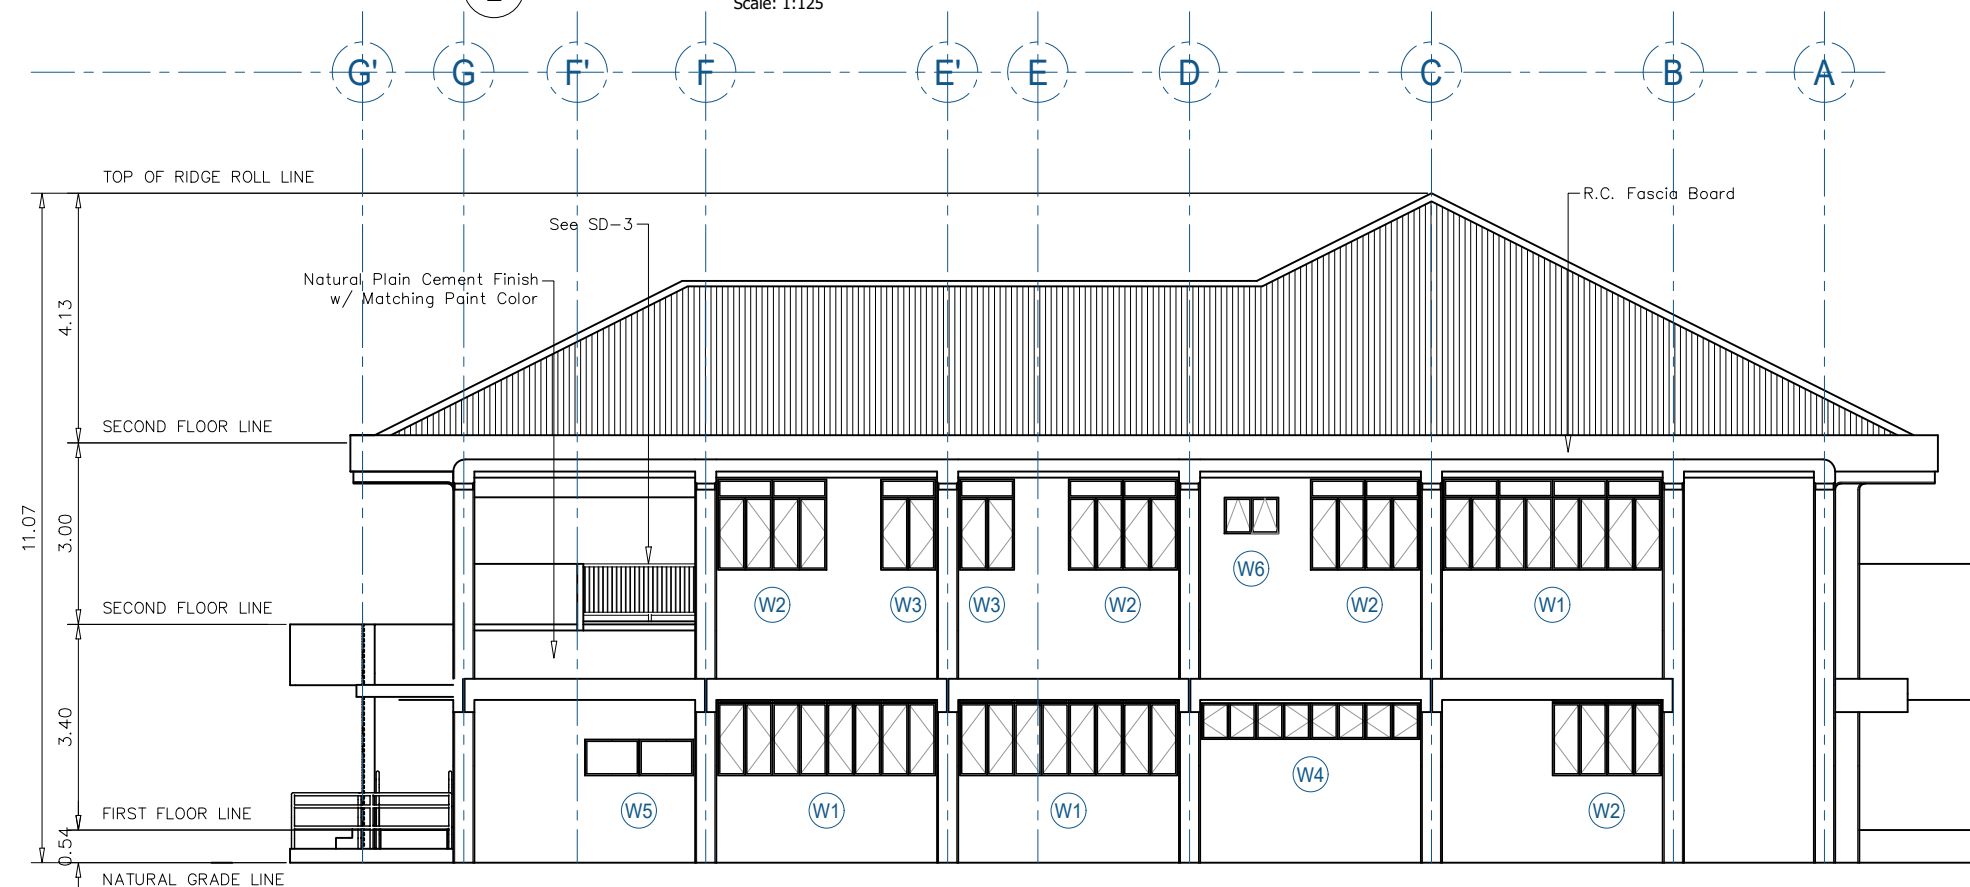


2 LEFT SIDE ELEVATION
Scale: 1:125



TIN :	Approved by :	# PTR :	Project Title :	Checked by :	Noted by :	Conformed by :	Approved by :	Concept by :	A7 05 SHEET NO. 05 27
PRC :		THIS DRAWING AND ITS CONTENTS ARE THE PROPERTY OF VISAYAS STATE UNIVERSITY. ANY REPRODUCTION OR USE OF THIS DRAWING WITHOUT THE WRITTEN PERMISSION OF THE ARCHITECT OF RECORD IS STRICTLY PROHIBITED. THE ARCHITECT OF RECORD ACCEPTS NO LIABILITY FOR ANY DAMAGE OR LOSS OF ANY KIND, INCLUDING BUT NOT LIMITED TO, THE LOSS OF OR DAMAGE TO ANY BUILDING OR OTHER PROPERTY, OR ANY PERSONAL INJURY OR DEATH, ARISING OUT OF OR RESULTING FROM THE USE OF THIS DRAWING, WHETHER SUCH DAMAGE OR LOSS OR INJURY OR DEATH IS CAUSED BY NEGLIGENCE OR OTHERWISE.	CONSTRUCTION OF ANIMAL TESTING FACILITY	Engr. MARIO LILIO P. VALENZONA	Dr. SANTIAGO T. PENA, Jr.	Dr. DANIEL LESLIE S. TAN	Dr. EDGARDO E. TULIN	AutoCAD by :	
PTR :								Date Started :	
Date :								Date Finished :	
Place :	Architect of Record		Location : VSU Main Campus, Baybay City, Leyte Philippines	DIRECTOR, PPO	DEAN, CVM	VP OF ADMINISTRATIVE AND FINANCE	VSU PRESIDENT	Place :	

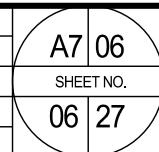  

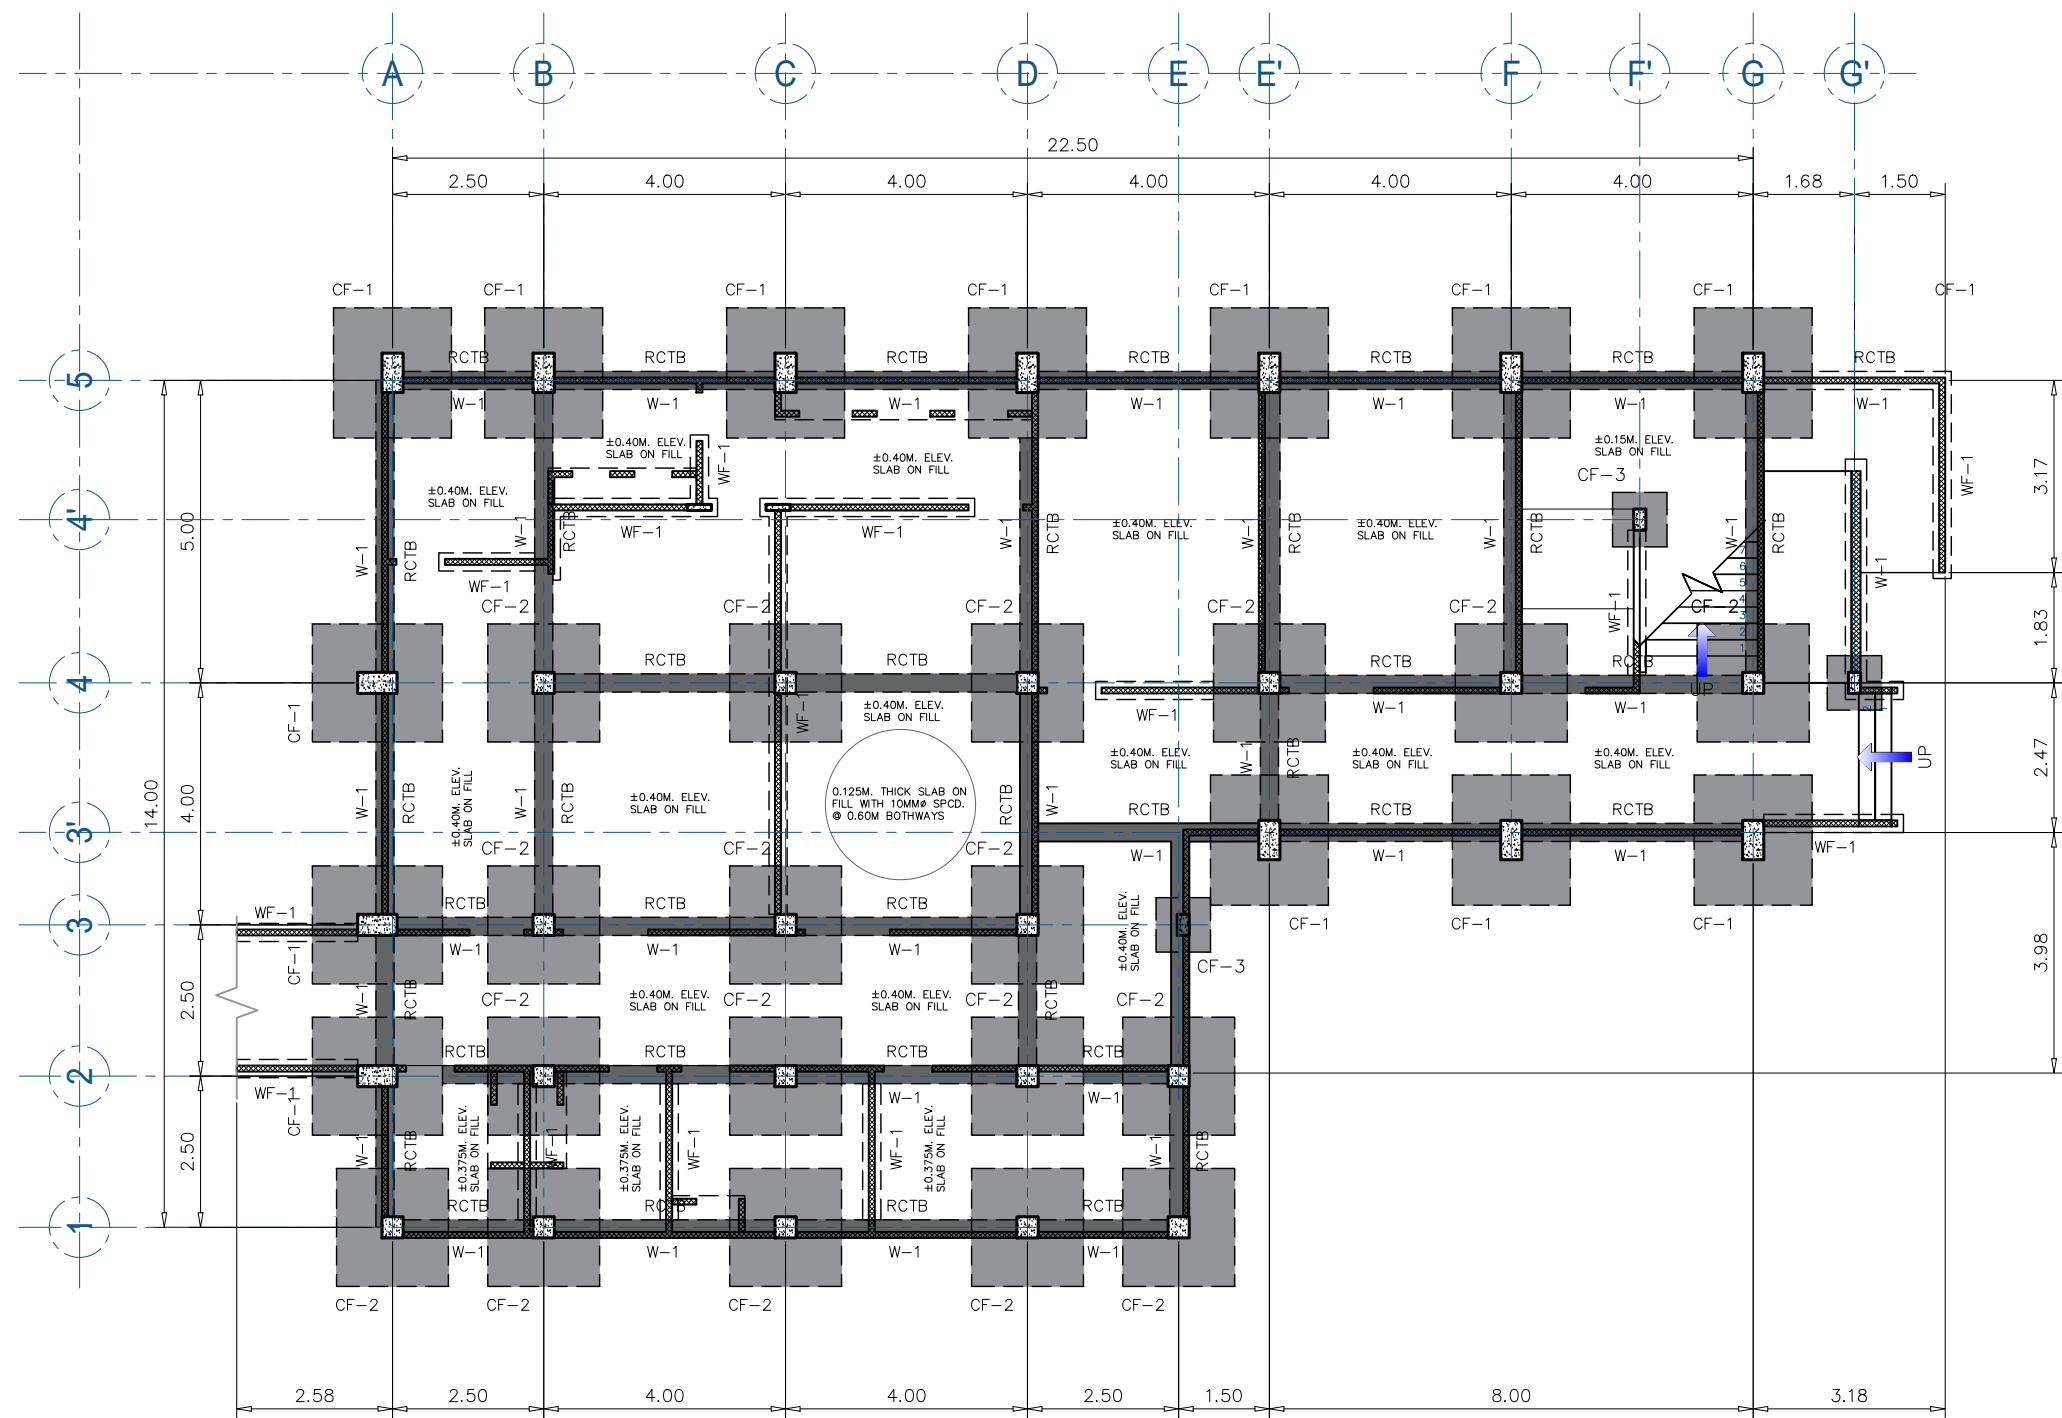


1 FOUNDATION PLAN
Scale: 1:125



TIN :	Approved by :	Project Title :	Checked by :	Noted by :	Conformed by :	Approved by :	Concept by :
PRC :		CONSTRUCTION OF ANIMAL TESTING FACILITY	Engr. MARIO LILIO P. VALENZONA	Dr. SANTIAGO T. PENA, Jr.	Dr. DANIEL LESLIE S. TAN	Dr. EDGARDO E. TULIN	AutoCAD by :
PTR :		Location : VSU Main Campus, Baybay City, Leyte Philippines	DIRECTOR, PPO	DEAN, CVM	VP OF ADMINISTRATIVE AND FINANCE	VSU PRESIDENT	Date Started :
Date :							Date Finished :
Place :	Structural Engineer						Place :


S7 01
SHEET NO.
08 27

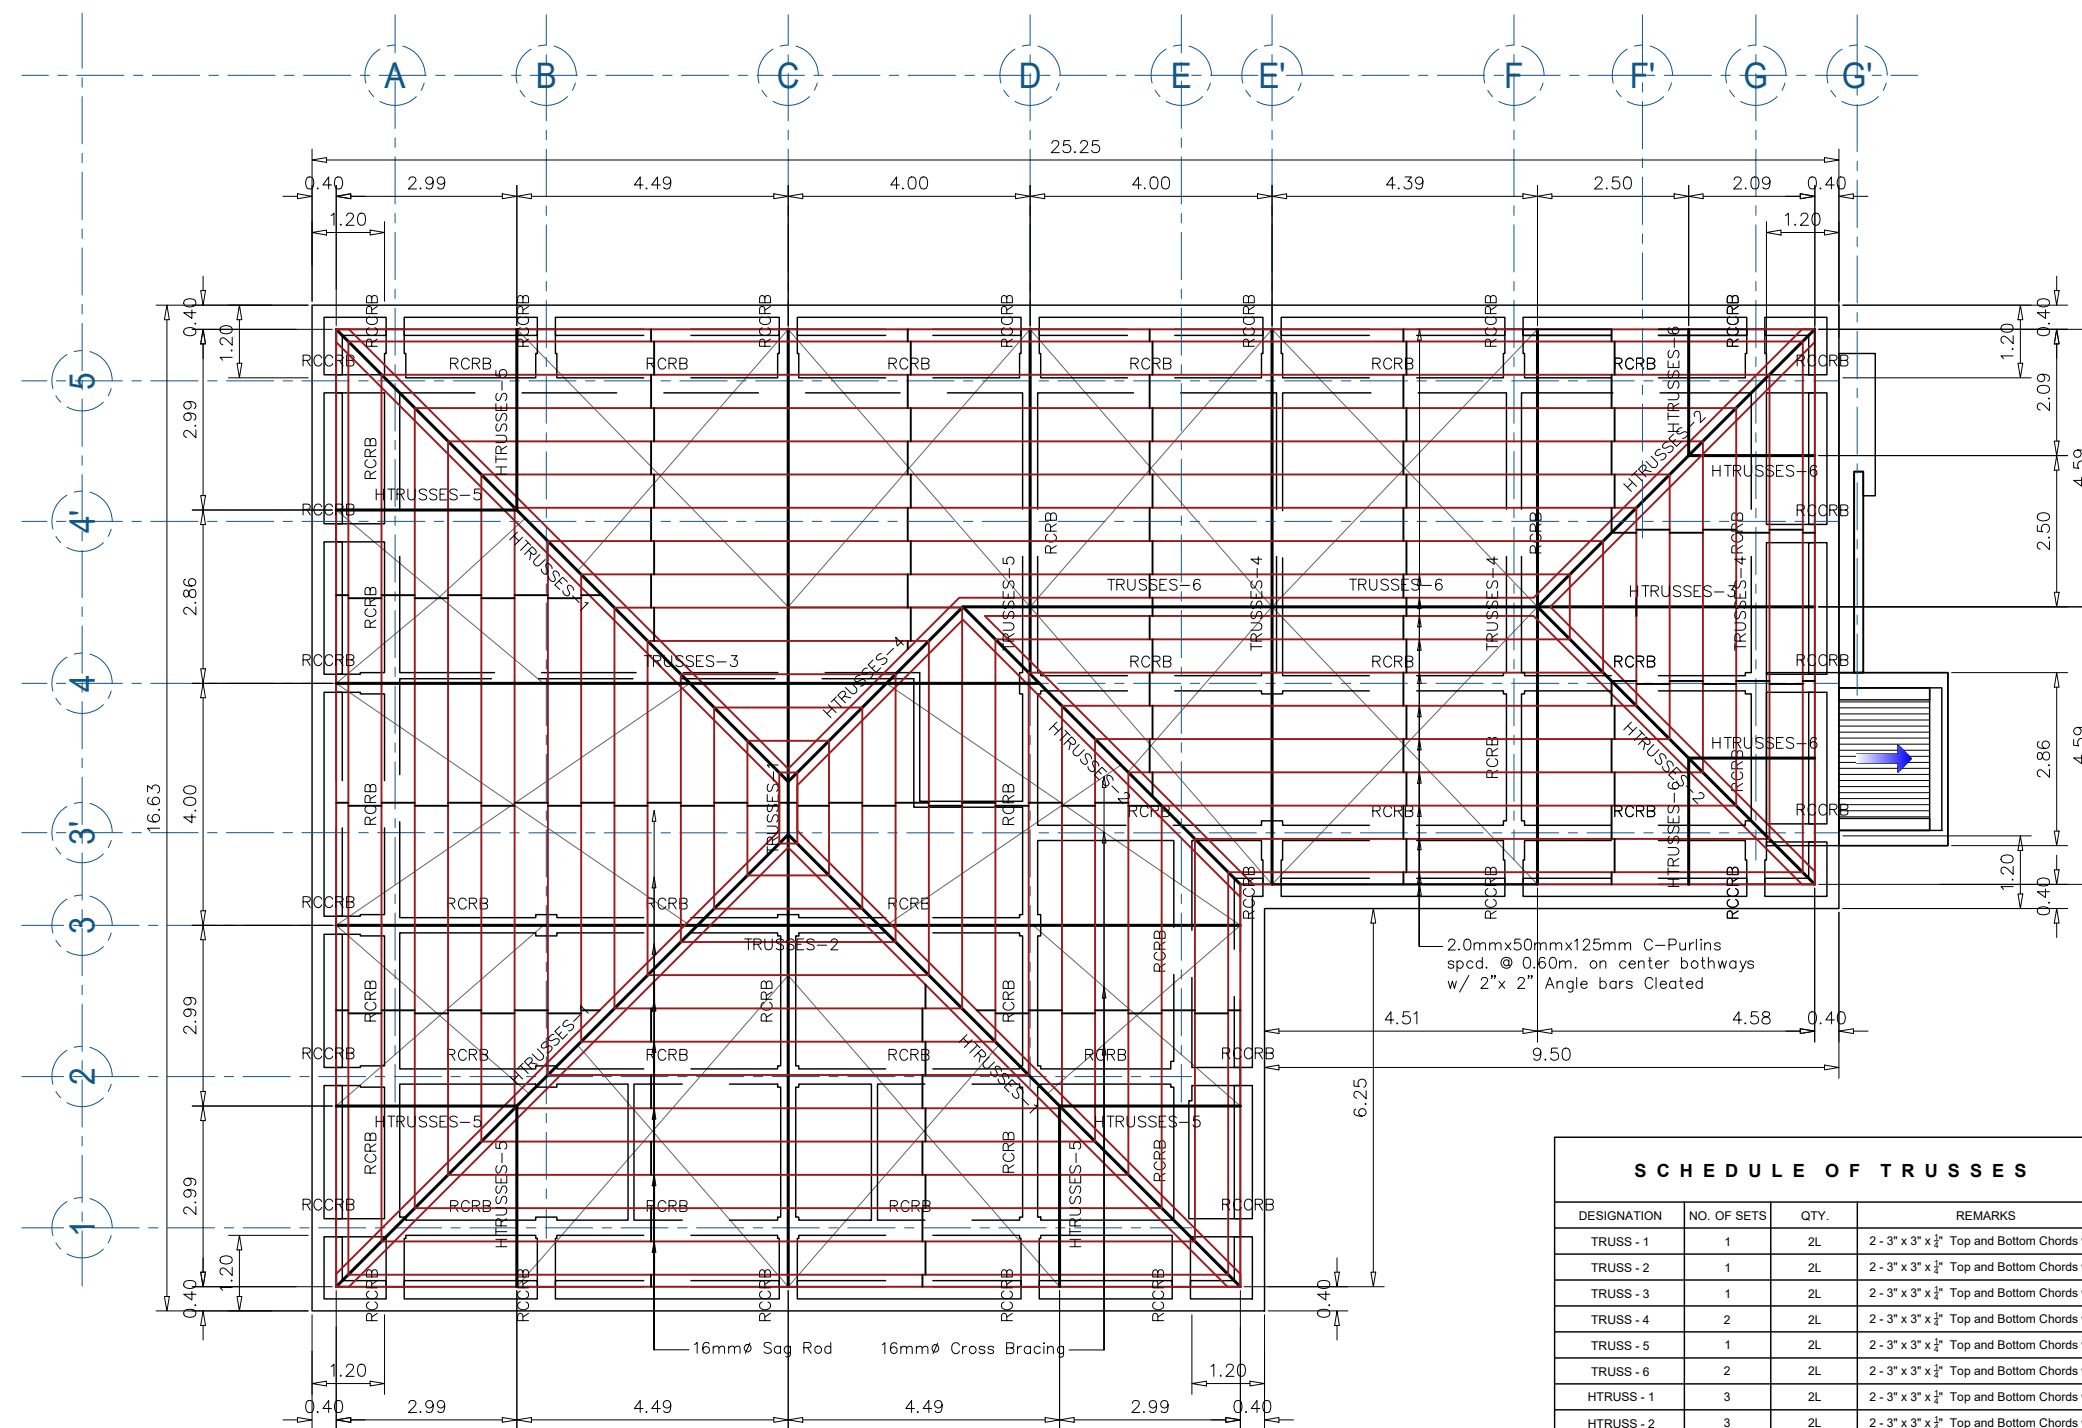

1 ROOF FRAMING PLAN
Scale: 1:125

SCHEDULE OF TRUSSES			
DESIGNATION	NO. OF SETS	QTY.	REMARKS
TRUSS - 1	1	2L	2 - 3" x 3" x 1/2" Top and Bottom Chords with 2 - 2"x 2" Web Members Angle Bars
TRUSS - 2	1	2L	2 - 3" x 3" x 1/2" Top and Bottom Chords with 2 - 2"x 2" Web Members Angle Bars
TRUSS - 3	1	2L	2 - 3" x 3" x 1/2" Top and Bottom Chords with 2 - 2"x 2" Web Members Angle Bars
TRUSS - 4	2	2L	2 - 3" x 3" x 1/2" Top and Bottom Chords with 2 - 2"x 2" Web Members Angle Bars
TRUSS - 5	1	2L	2 - 3" x 3" x 1/2" Top and Bottom Chords with 2 - 2"x 2" Web Members Angle Bars
TRUSS - 6	2	2L	2 - 3" x 3" x 1/2" Top and Bottom Chords with 2 - 2"x 2" Web Members Angle Bars
HTRUSS - 1	3	2L	2 - 3" x 3" x 1/2" Top and Bottom Chords with 2 - 2"x 2" Web Members Angle Bars
HTRUSS - 2	3	2L	2 - 3" x 3" x 1/2" Top and Bottom Chords with 2 - 2"x 2" Web Members Angle Bars
HTRUSS - 3	1	2L	2 - 3" x 3" x 1/2" Top and Bottom Chords with 2 - 2"x 2" Web Members Angle Bars
HTRUSS - 4	1	2L	2 - 3" x 3" x 1/2" Top and Bottom Chords with 2 - 2"x 2" Web Members Angle Bars
HTRUSS - 5	6	2L	2 - 3" x 3" x 1/2" Top and Bottom Chords with 2 - 2"x 2" Web Members Angle Bars
HTRUSS - 6	4	2L	2 - 3" x 3" x 1/2" Top and Bottom Chords with 2 - 2"x 2" Web Members Angle Bars

S C H E D U L E O F R O O F B E A M S										
BEAM MARK	BEAM DIMENSIONS (meters)		S T E E L R E I N F O R C E M E N T S						S T I R R U P S	
			REBAR (mmØ)	LEFT SUPPORT		MID - SPAN		RIGHT SUPPORT		
	b	h		TOP	BOTTOM	TOP	BOTTOM	TOP		BOTTOM
RCRB	0.25	0.40	16mmØ	3	2	2	2	3	2	5 - 0.05m, 3 - 0.10m, 1 - 0.15m, rest @ 0.20m.
RCCRB	0.30	0.40	16mmØ	3	2	2	2	2	2	6 - 0.05m, 4 - 0.10m, 2 - 0.15m, rest @ 0.20m.

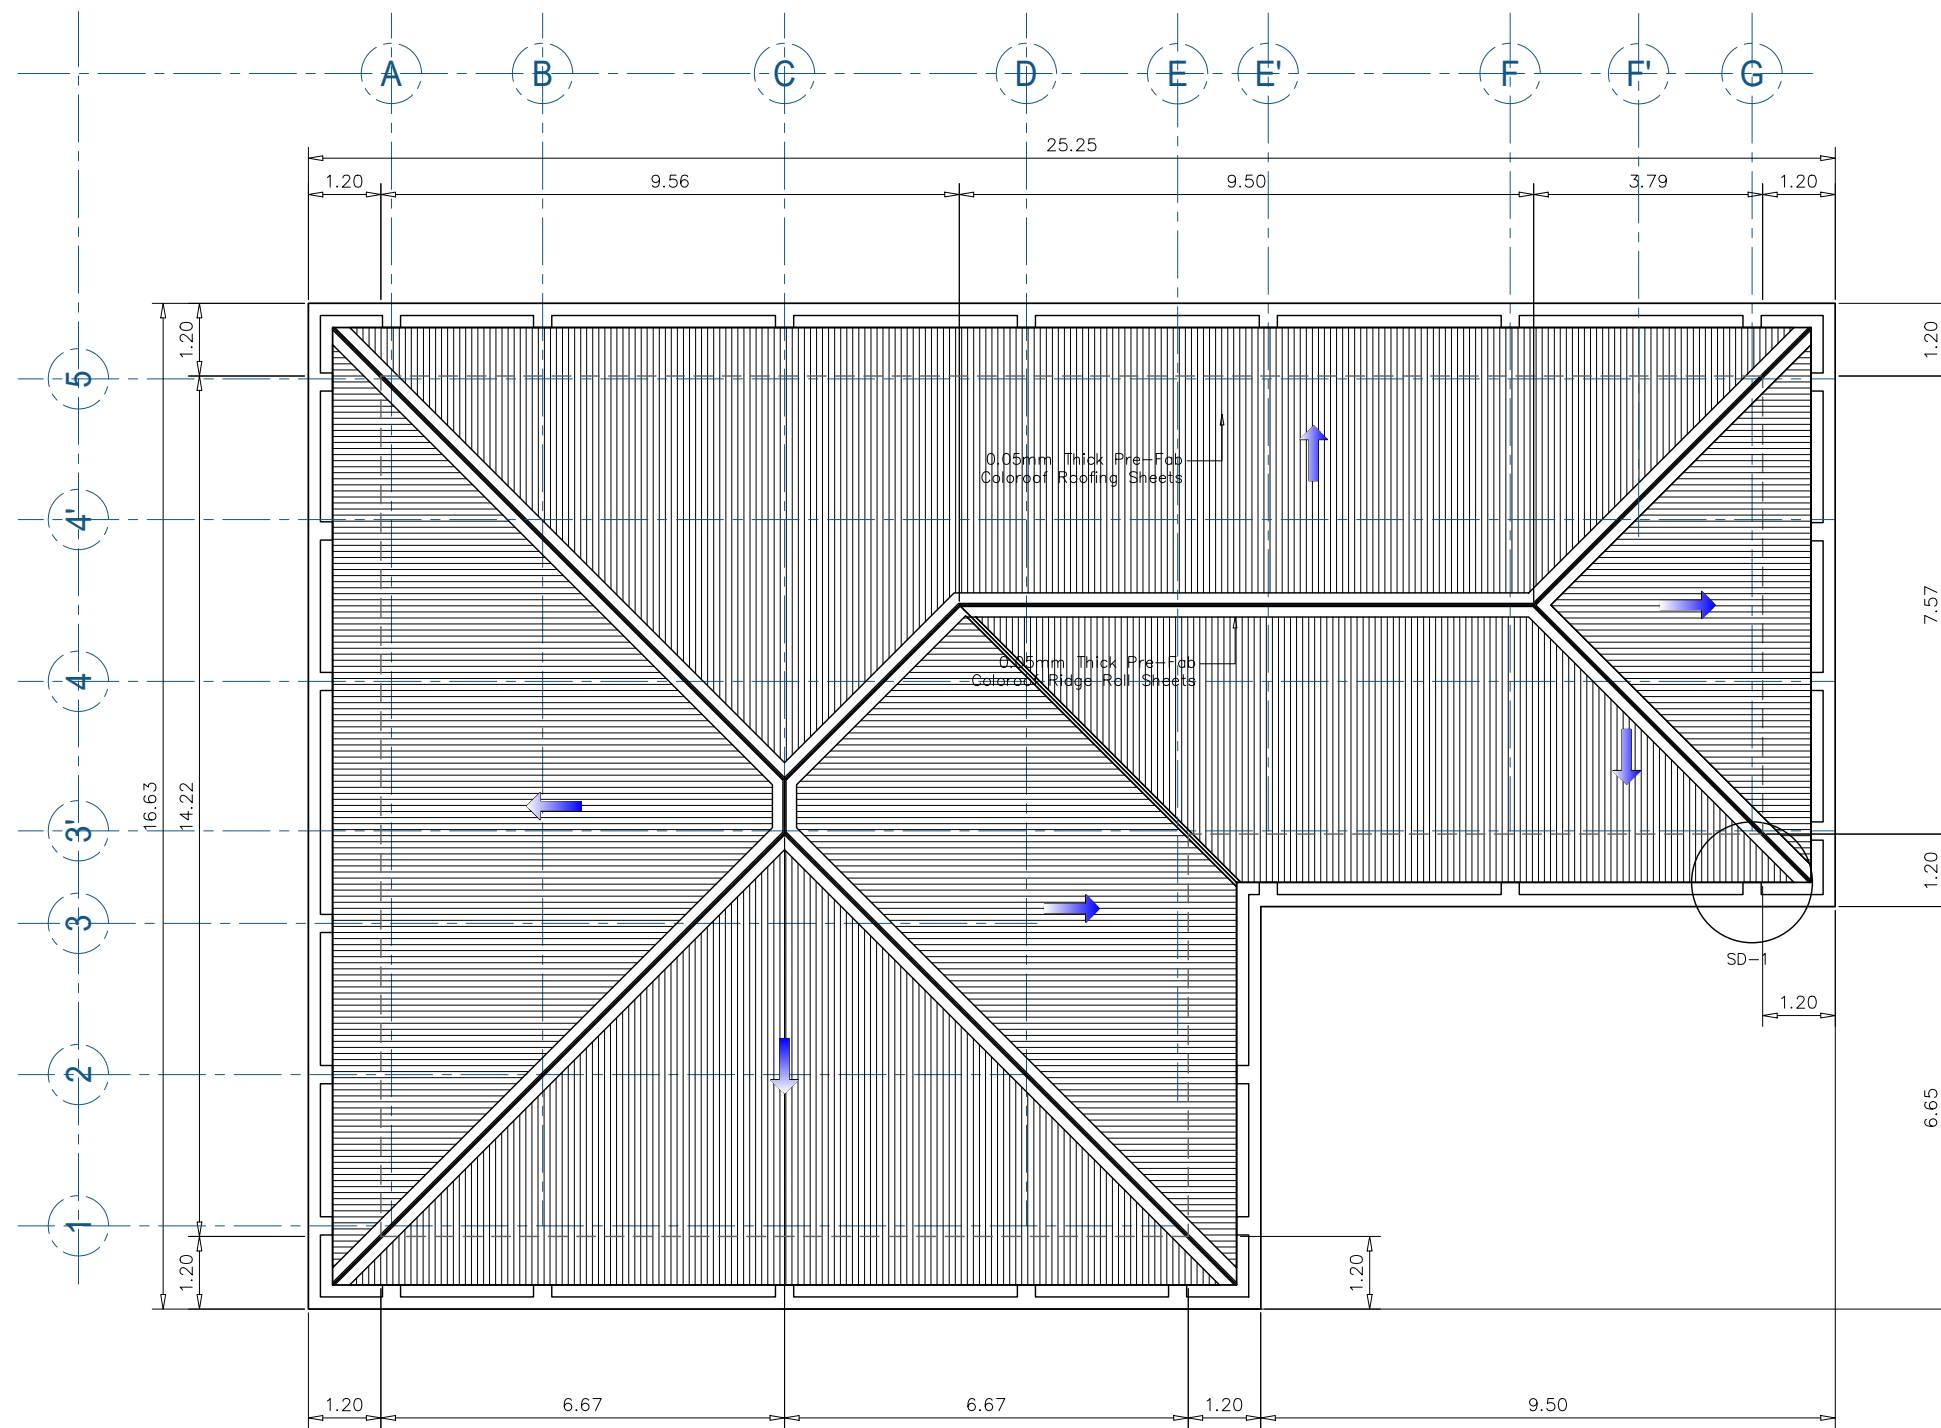

1 ROOF PLAN
Scale: 1:125



TIN :
PRC :
PTR :
Date :
Place :

Approved by :

Structural Engineer

NOTES:
THIS DRAWING AND SPECIFICATIONS ARE THE PROPERTY OF VISAYAS STATE UNIVERSITY. ANY REUSE, REPRODUCTION, OR ALTERATION WITHOUT THE WRITTEN PERMISSION OF THE ARCHITECT IS STRICTLY PROHIBITED. THE USER ASSUMES ALL LIABILITY FOR ANY ERRORS OR OMISSIONS IN THIS DRAWING. THE ARCHITECT'S OFFICE SHALL NOT BE RESPONSIBLE FOR ANY CONSEQUENCES ARISING FROM THE USE OF THIS DRAWING.

Project Title :
CONSTRUCTION OF ANIMAL TESTING FACILITY
Location : VSU Main Campus, Baybay City, Leyte Philippines

Checked by :
Engr. MARIO LILIO P. VALENZONA
DIRECTOR, PPO

Noted by :
Dr. SANTIAGO T. PENA, Jr.
DEAN, CVM


Conformed by :
Dr. DANIEL LESLIE S. TAN
VP OF ADMINISTRATIVE AND FINANCE

Approved by :
Dr. EDGARDO E. TULIN
VSU PRESIDENT






Concept by :
AutoCAD by :
Date Started :
Date Finished :
Place :

S7 04
SHEET NO.
11 27


NOTE: 6"CHB Wall w/ 12mm.
Vertical RSB spacing @ 0.80m
Ties on 10mm. Horizontal Bars
spacing @ every 3 Layers.

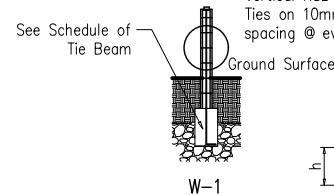

NOTE : 4" CHB Wall w/ 12mm.
Vertical RSB spacing @ 0.80m
Ties on 10mm. Horizontal Bars
spacing @ every 3 Layers.

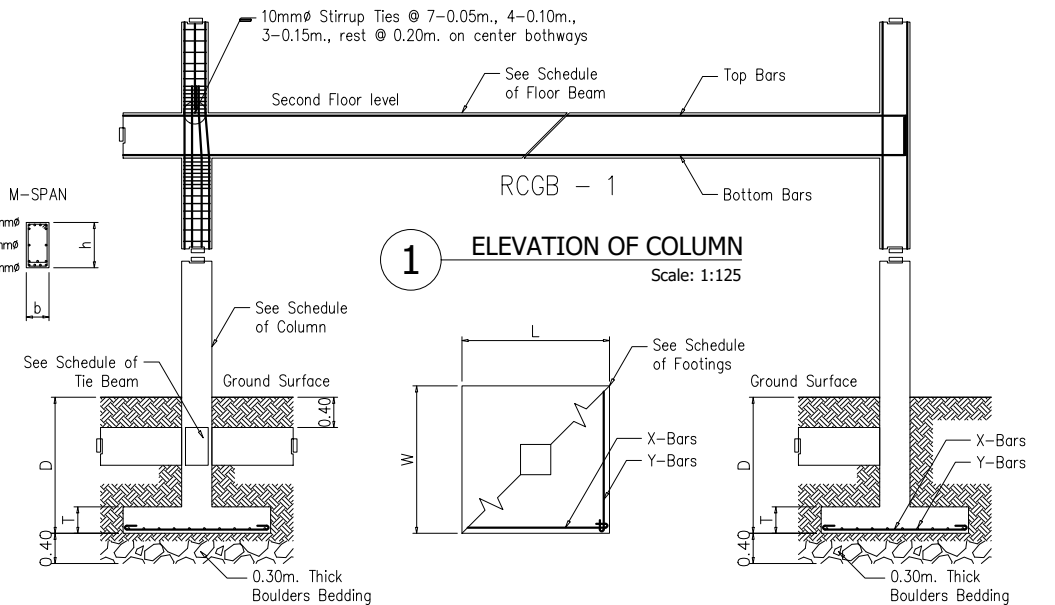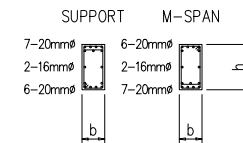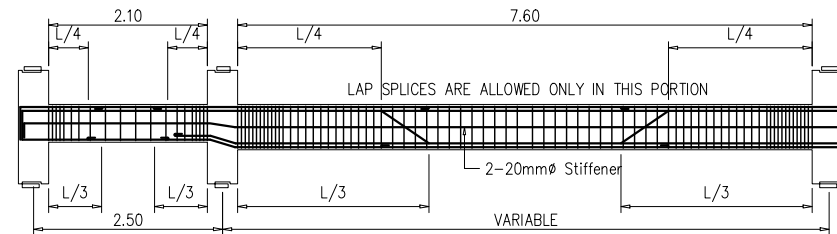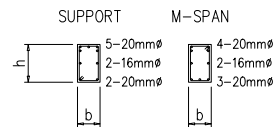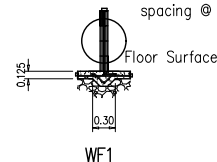

3 DETAIL OF TIE BEAM
Scale: 1:125

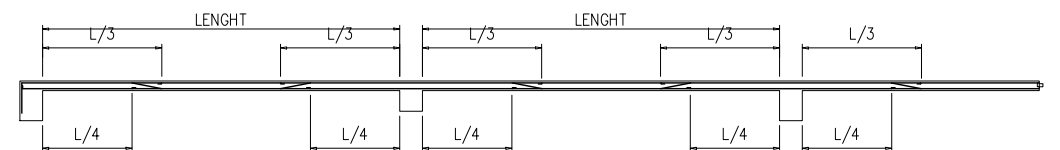

4 TYPICAL FOOTING DETAIL
Scale: 1:125

5 TYPICAL SLAB SECTION
Scale: 1:125

SCHEDULE OF FLOOR BEAMS

S C H E D U L E O F F L O O R B E A M S										
BEAM MARK	BEAM DIMENSIONS (meters)		S T E E L R E I N F O R C E M E N T S						S T I R R U P S	
			REBAR (mmØ)	LEFT SUPPORT		MID - SPAN		RIGHT SUPPORT		
	b	h		TOP	BOTTOM	TOP	BOTTOM	TOP		BOTTOM
RCFB - 1	0.30	0.60	20mmØ	4	4	2	4	4	4	8 - 0.05m., 6 - 0.10m. rest @ 0.15m.
RCFB - 1A	0.30	0.50	20mmØ	4	4	2	4	4	4	7 - 0.05m., 5 - 0.10m., 2 - 0.15m., rest @ 0.20m.
RCFB - 2	0.30	0.45	20mmØ	4	4	2	4	4	4	6 - 0.05m., 4 - 0.10m., 2 - 0.15m., rest @ 0.20m.
RCFB - 3	0.25	0.45	20mmØ	3	2	2	3	3	2	5 - 0.05m., 3 - 0.10m., 1 - 0.15m., rest @ 0.20m.
RCCB - 1	0.30	0.50	20mmØ	4	4	2	4	4	4	8 - 0.05m., 6 - 0.10m., 4 - 0.15m., rest @ 0.20m.
RCCB - 2	0.30	0.45	16mmØ	4	4	2	4	4	4	6 - 0.05m., 4 - 0.10m., 2 - 0.15m., rest @ 0.20m.

SCHEDULE OF FOOTINGS

FOOTING MARK	FOOTING DIMENSIONS (meters)				REINFORCEMENTS		REMARKS
	LENGTH (L)	WIDTH (W)	DEPTH (D)	THICKNESS (T)	BAR - X	BAR - Y	
F - 1	2.15	1.95	1.80	0.35	10 - 20mmØ	11 - 20mmØ	SQUARE FOOTING
F - 2	1.95	1.85	1.80	0.30	9 - 20mmØ	10 - 20mmØ	- DO -
F - 3	0.95	0.95	0.95	0.25	5 - 16mmØ	5 - 16mmØ	- DO -

SCHEDULE OF TIE BEAM

S C H E D U L E O F T I E B E A M										
BEAM MARK	BEAM DIMENSIONS (meters)		S T E E L R E I N F O R C E M E N T S						S T I R R U P S	
			REBAR (mmØ)	LEFT SUPPORT		MID - SPAN		RIGHT SUPPORT		
	b	h		TOP	BOTTOM	TOP	BOTTOM	TOP		BOTTOM
RCTB	0.20	0.40	16mmØ	6	6	6	6	6	6	6 - 0.05m., 4 - 0.10m., 2 - 0.15m., rest @ 0.20m.

SCHEDULE OF SLABS

S C H E D U L E O F S L A B S																	
FLOOR LEVEL	SLAB MARK	THICKNESS (meters)	REBAR SPACING ALONG SHORT DIRECTION (mm)						REBAR SPACING ALONG LONG DIRECTION (mm)						REMARKS		
			REBAR (mmØ)	LEFT SUPPORT		MID - SPAN		RIGHT SUPPORT		REBAR (mmØ)	LEFT SUPPORT		MID - SPAN			RIGHT SUPPORT	
				TOP	BOTTOM	TOP	BOTTOM	TOP	BOTTOM		TOP	BOTTOM	TOP	BOTTOM		TOP	BOTTOM
2ND LEVEL																	
	S - 1	0.10	10mmØ	125	125		125	125	125	12mmØ	125	125		125	125	125	ONE - WAY
	S - 2	0.10	10mmØ	125	125		125	125	125	12mmØ	125	125		125	125	125	TWO - WAY

SCHEDULE OF COLUMNS

LEVEL	C1	C2	C3
FOUNDATION TO 2ND FLOOR LEVEL	MAIN BAR : 12 - 20mmØ TIES : 10mmØ @ 8 - 0.05m., 6 - 0.10m., Rest 0.15m. O.C.	MAIN BAR : 8 - 20mmØ TIES : 10mmØ @ 8 - 0.05m., 4 - 0.10m., Rest 0.15m. O.C.	MAIN BAR : 6 - 16mmØ TIES : 10mmØ @ 5 - 0.05m., 3 - 0.10m., 2 - 0.15m., Rest 0.20m. O.C.
2ND FLOOR TO ROOF LEVEL	MAIN BAR : 12 - 16mmØ TIES : 10mmØ @ 8 - 0.05m., 6 - 0.10m., 2 - 0.15m., Rest 0.20m. O.C.	MAIN BAR : 8 - 16mmØ TIES : 10mmØ @ 8 - 0.05m., 4 - 0.10m., 2 - 0.15m., Rest 0.20m. O.C.	



TIN :
PRC :
PTR :
Date :
Place :
Approved by :
Structural Engineer

11

THIS DRAWING AND SPECIFICATION ARE THE PROPERTY OF VISAYAS STATE UNIVERSITY. ANY REPRODUCTION OR USE OF THIS DRAWING OR SPECIFICATION WITHOUT THE WRITTEN PERMISSION OF VISAYAS STATE UNIVERSITY IS PROHIBITED. ANY REPRODUCTION OR USE OF THIS DRAWING OR SPECIFICATION WITHOUT THE WRITTEN PERMISSION OF VISAYAS STATE UNIVERSITY IS PROHIBITED.

Project Title :
CONSTRUCTION OF ANIMAL TESTING FACILITY
Location : VSU Main Campus, Baybay City, Leyte Philippines

Checked by :
Engr. MARIO LILIO P. VALENZONA
DIRECTOR, PPO

Noted by :
Dr. SANTIAGO T. PENA, Jr.
DEAN, CVM

Conformed by :
Dr. DANIEL LESLIE S. TAN
VP OF ADMINISTRATIVE AND FINANCE














Approved by :
Dr. EDGARDO E. TULIN
VSU PRESIDENT

Concept by :
AutoCAD by :
Date Started :
Date Finished :
Place :

S7 05

SHEET NO.

12 27

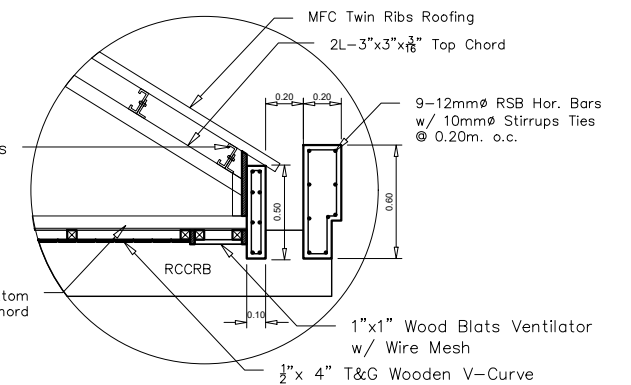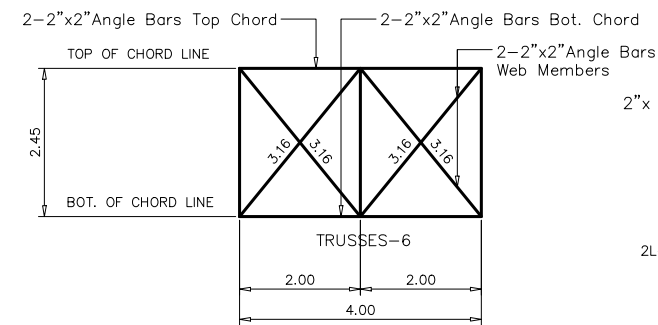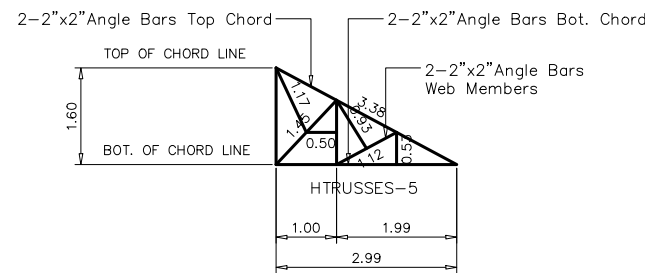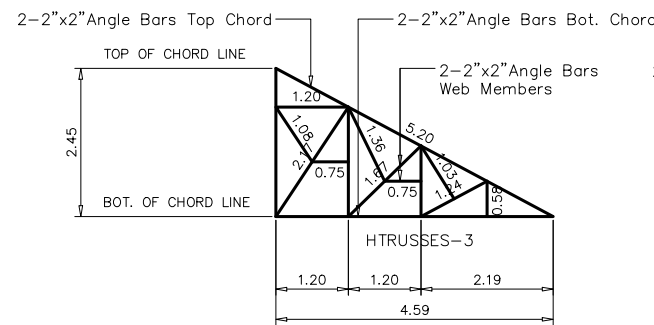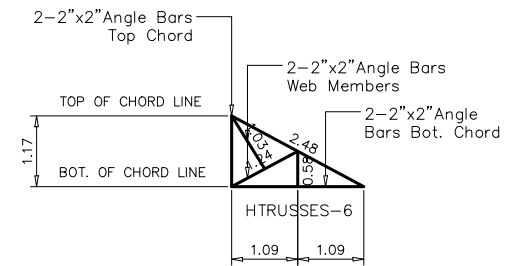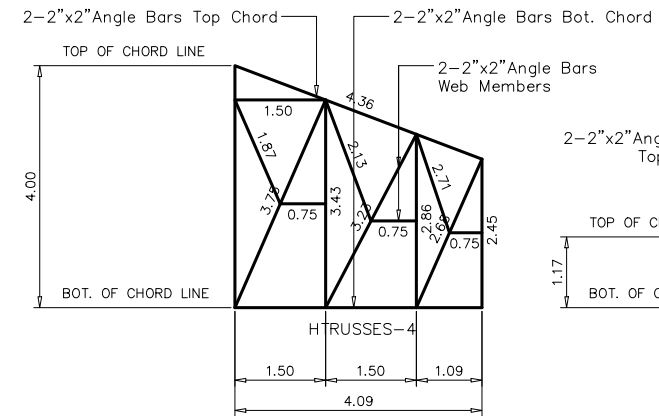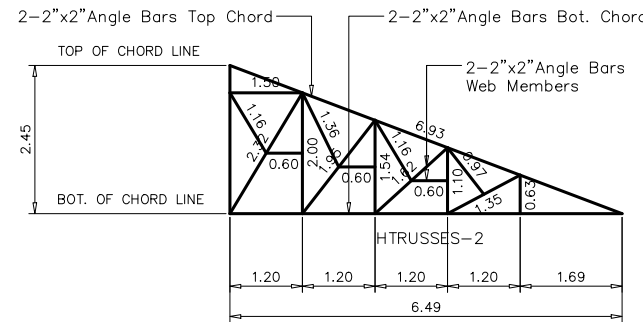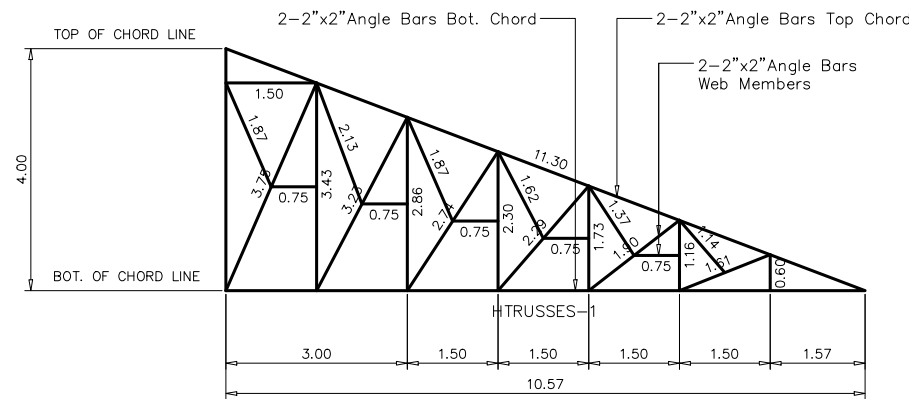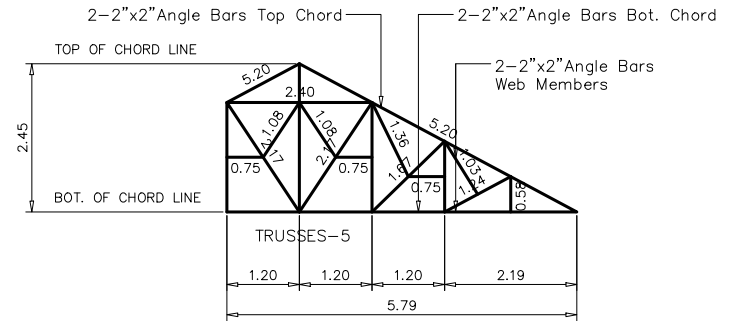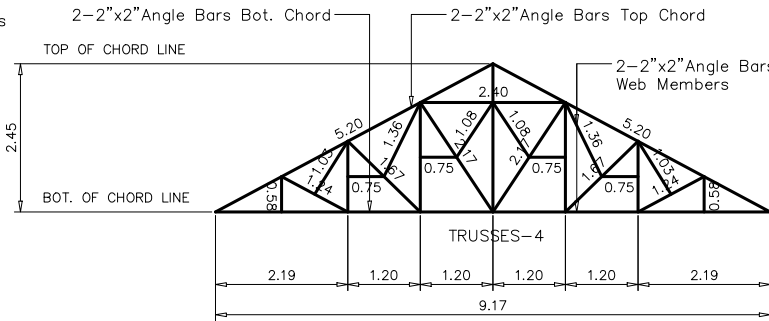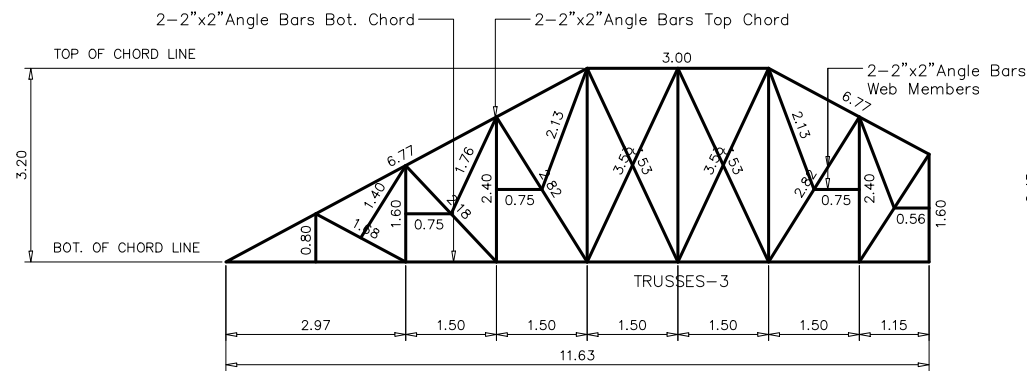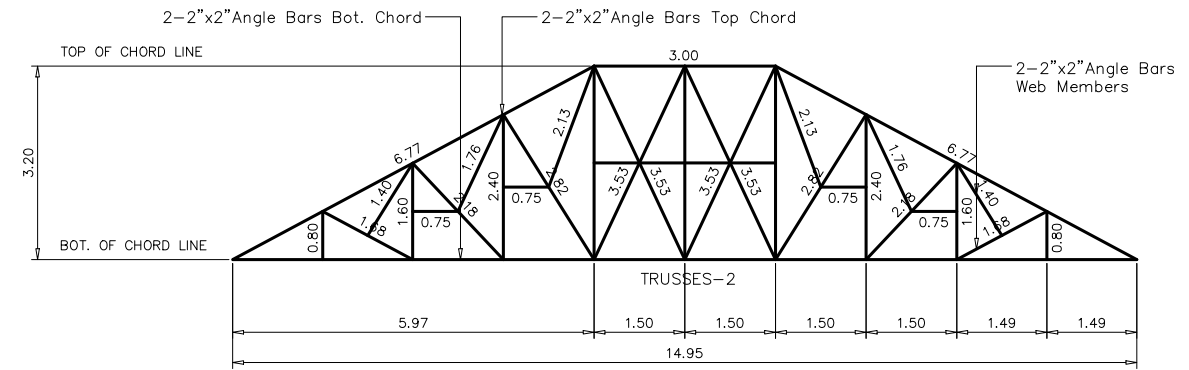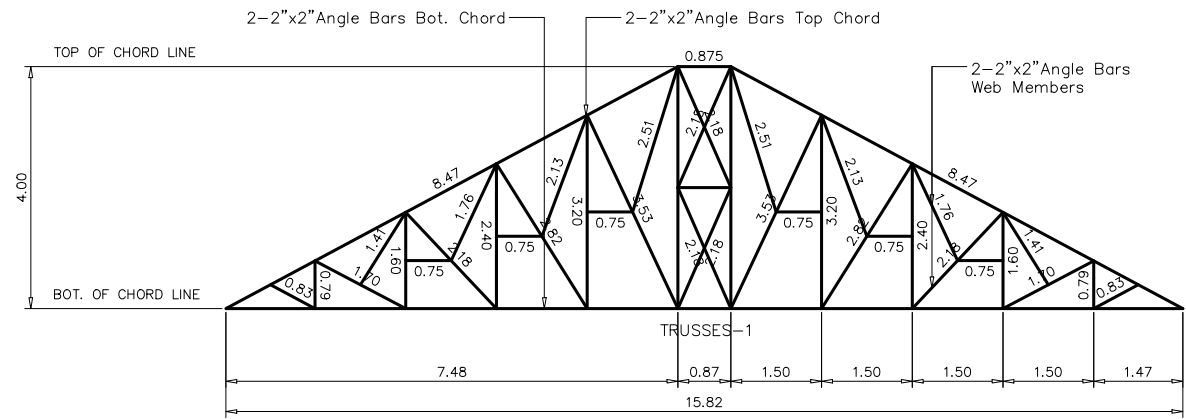

1 DETAIL OF STEEL TRUSSES
Scale: 1:125

2 DETAIL OF R.C. FASCIA BOARD
Scale: 1:40



TIN:	Approved by:
PRC:	
PTR:	
Date:	
Place:	Structural Engineer

NOTES:
1. ALL DIMENSIONS ARE IN METERS UNLESS OTHERWISE SPECIFIED.
2. ALL DIMENSIONS ARE TO FACE UNLESS OTHERWISE SPECIFIED.
3. ALL DIMENSIONS ARE TO CENTERLINE UNLESS OTHERWISE SPECIFIED.
4. ALL DIMENSIONS ARE TO CENTERLINE UNLESS OTHERWISE SPECIFIED.
5. ALL DIMENSIONS ARE TO CENTERLINE UNLESS OTHERWISE SPECIFIED.

Project Title:	Checked by:
CONSTRUCTION OF ANIMAL TESTING FACILITY	Engr. MARIO LILIO P. VALENZONA
Location:	Noted by:
VSU Main Campus, Baybay City, Leyte Philippines	Dr. SANTIAGO T. PENA, Jr.







Checked by:	Noted by:
Engr. MARIO LILIO P. VALENZONA	Dr. SANTIAGO T. PENA, Jr.

Noted by:	Conformed by:
Dr. SANTIAGO T. PENA, Jr.	Dr. DANIEL LESLIE S. TAN

Conformed by:	Approved by:
Dr. DANIEL LESLIE S. TAN	Dr. EDGARDO E. TULIN

Approved by:	Concept by:
Dr. EDGARDO E. TULIN	AutoCAD by:
	Date Started:
	Date Finished:
	Place:

S7 06
SHEET NO.
13 27

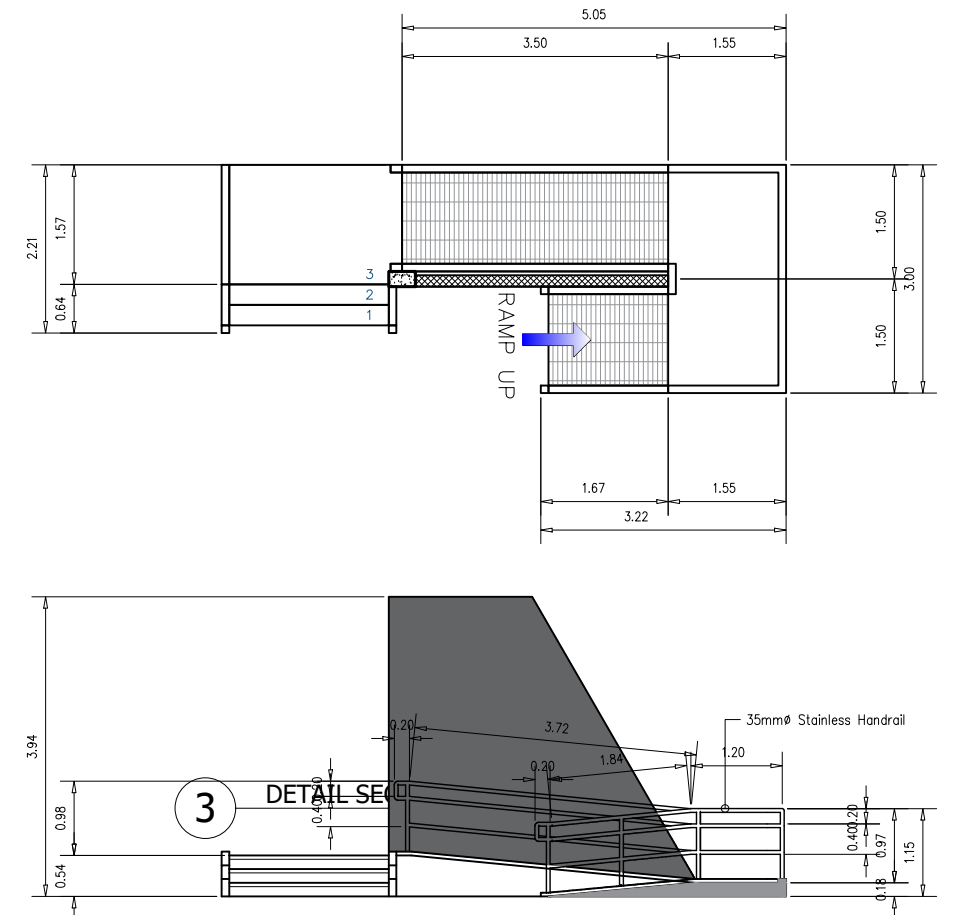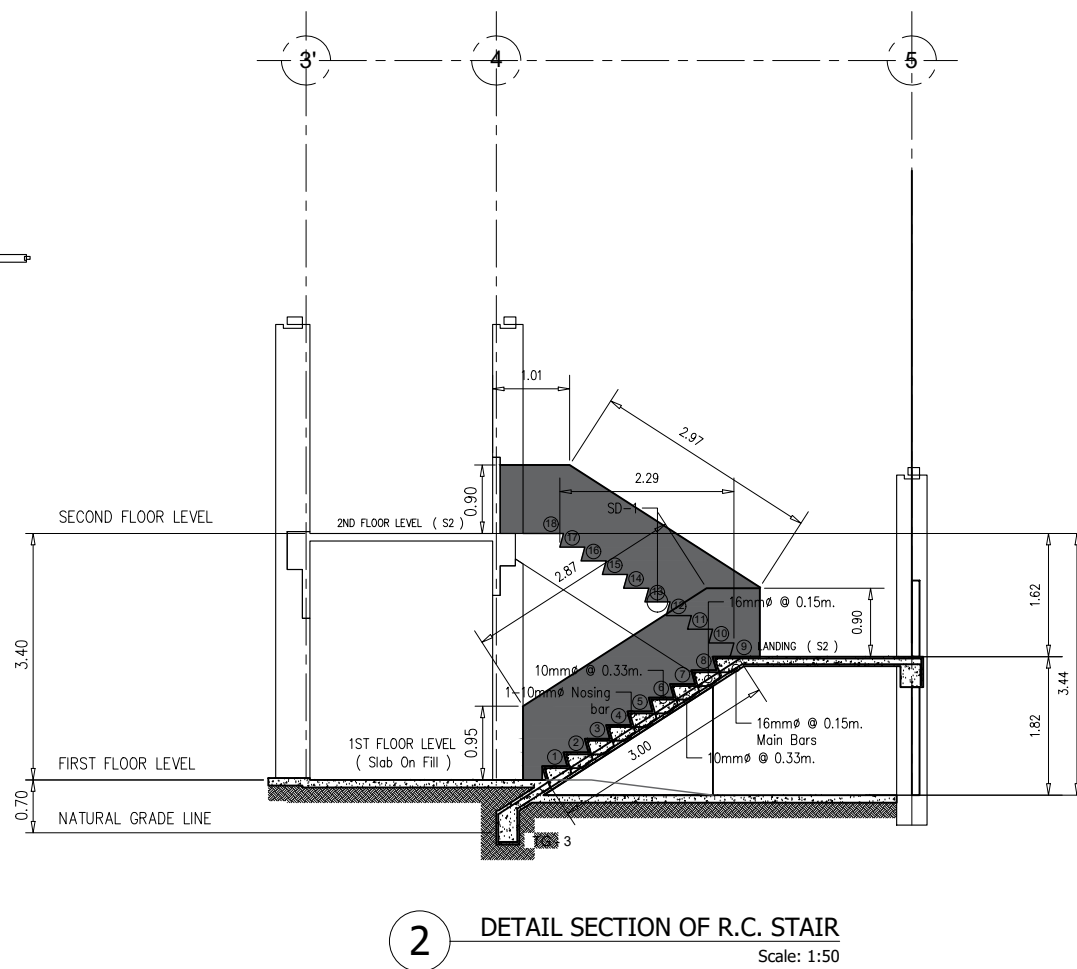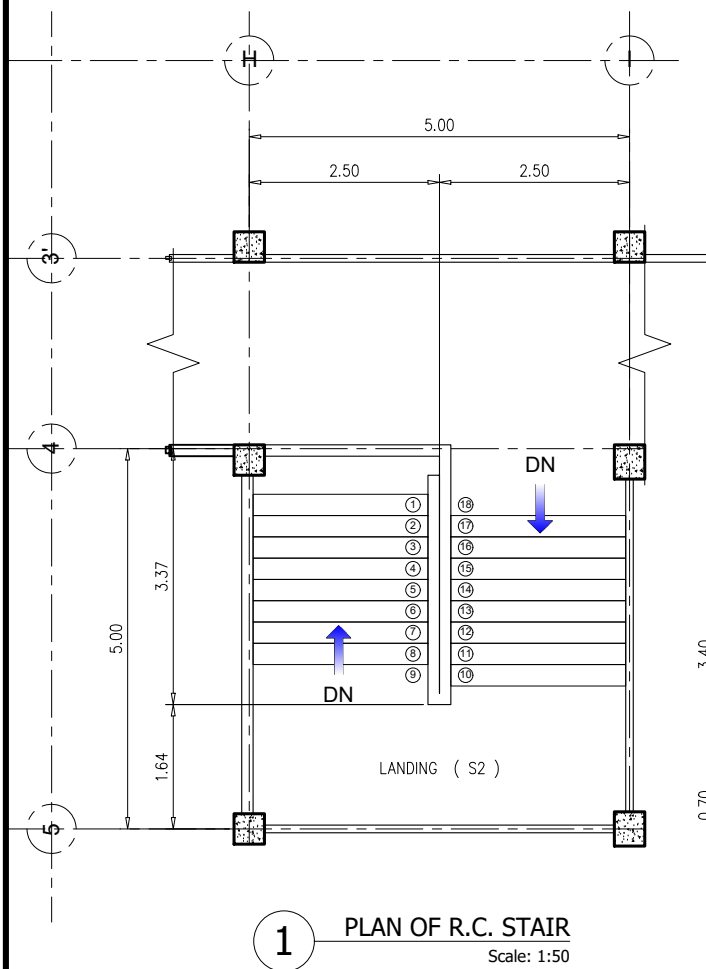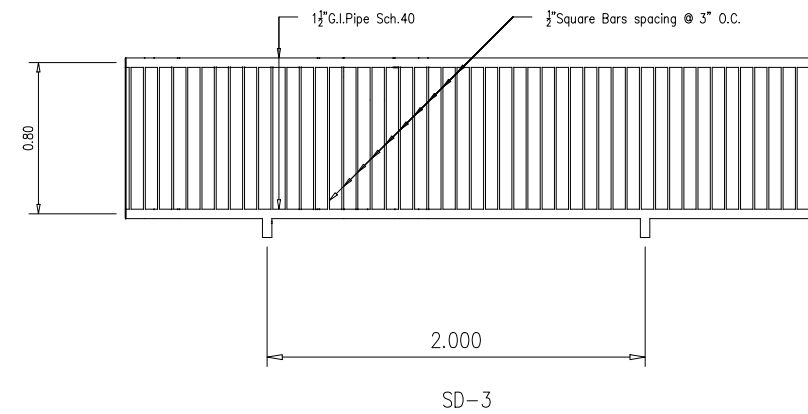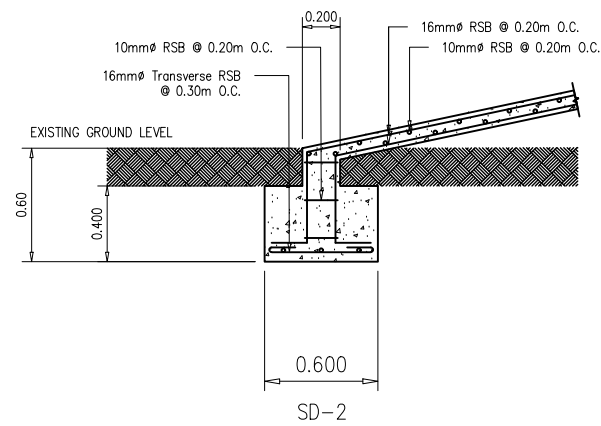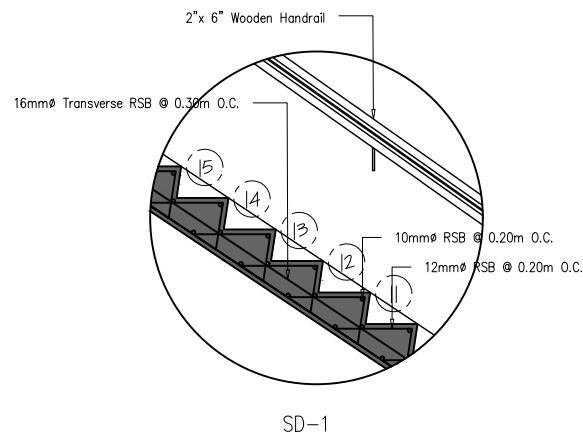

TIN :	Approved by :
PRC :	
PTR :	
Date :	
Place :	Structural Engineer

THESE DRAWINGS AND SPECIFICATIONS ARE PREPARED BY THE ARCHITECTURAL DIVISION OF THE VISAYAS STATE UNIVERSITY. THEY ARE SUBJECT TO CHANGE WITHOUT NOTICE. THE ARCHITECTURAL DIVISION IS NOT RESPONSIBLE FOR THE ACCURACY OF THE INFORMATION PROVIDED HEREIN. THE ARCHITECTURAL DIVISION IS NOT RESPONSIBLE FOR THE ACCURACY OF THE INFORMATION PROVIDED HEREIN. THE ARCHITECTURAL DIVISION IS NOT RESPONSIBLE FOR THE ACCURACY OF THE INFORMATION PROVIDED HEREIN.

Project Title :	Checked by :	Noted by :	Conformed by :	Approved by :	Concept by :
CONSTRUCTION OF ANIMAL TESTING FACILITY	Engr. MARIO LILIO P. VALENZONA	Dr. SANTIAGO T. PENA, Jr.	Dr. DANIEL LESLIE S. TAN	Dr. EDGARDO E. TULIN	AutoCAD by :
Location : VSU Main Campus, Baybay City, Leyte, Philippines	DIRECTOR, PPO	DEAN, CVM	VP OF ADMINISTRATIVE AND FINANCE	VSU PRESIDENT	Date Started :

Checked by :	Noted by :	Conformed by :	Approved by :	Concept by :
Engr. MARIO LILIO P. VALENZONA	Dr. SANTIAGO T. PENA, Jr.	Dr. DANIEL LESLIE S. TAN	Dr. EDGARDO E. TULIN	AutoCAD by :
DIRECTOR, PPO	DEAN, CVM	VP OF ADMINISTRATIVE AND FINANCE	VSU PRESIDENT	Date Started :


Checked by :	Noted by :	Conformed by :	Approved by :	Concept by :
Engr. MARIO LILIO P. VALENZONA	Dr. SANTIAGO T. PENA, Jr.	Dr. DANIEL LESLIE S. TAN	Dr. EDGARDO E. TULIN	AutoCAD by :
DIRECTOR, PPO	DEAN, CVM	VP OF ADMINISTRATIVE AND FINANCE	VSU PRESIDENT	Date Started :

Checked by :	Noted by :	Conformed by :	Approved by :	Concept by :
Engr. MARIO LILIO P. VALENZONA	Dr. SANTIAGO T. PENA, Jr.	Dr. DANIEL LESLIE S. TAN	Dr. EDGARDO E. TULIN	AutoCAD by :
DIRECTOR, PPO	DEAN, CVM	VP OF ADMINISTRATIVE AND FINANCE	VSU PRESIDENT	Date Started :

Checked by :	Noted by :	Conformed by :	Approved by :	Concept by :
Engr. MARIO LILIO P. VALENZONA	Dr. SANTIAGO T. PENA, Jr.	Dr. DANIEL LESLIE S. TAN	Dr. EDGARDO E. TULIN	AutoCAD by :
DIRECTOR, PPO	DEAN, CVM	VP OF ADMINISTRATIVE AND FINANCE	VSU PRESIDENT	Date Started :

Checked by :	Noted by :	Conformed by :	Approved by :	Concept by :
Engr. MARIO LILIO P. VALENZONA	Dr. SANTIAGO T. PENA, Jr.	Dr. DANIEL LESLIE S. TAN	Dr. EDGARDO E. TULIN	AutoCAD by :
DIRECTOR, PPO	DEAN, CVM	VP OF ADMINISTRATIVE AND FINANCE	VSU PRESIDENT	Date Started :


S7 07
SHEET NO.
14 27

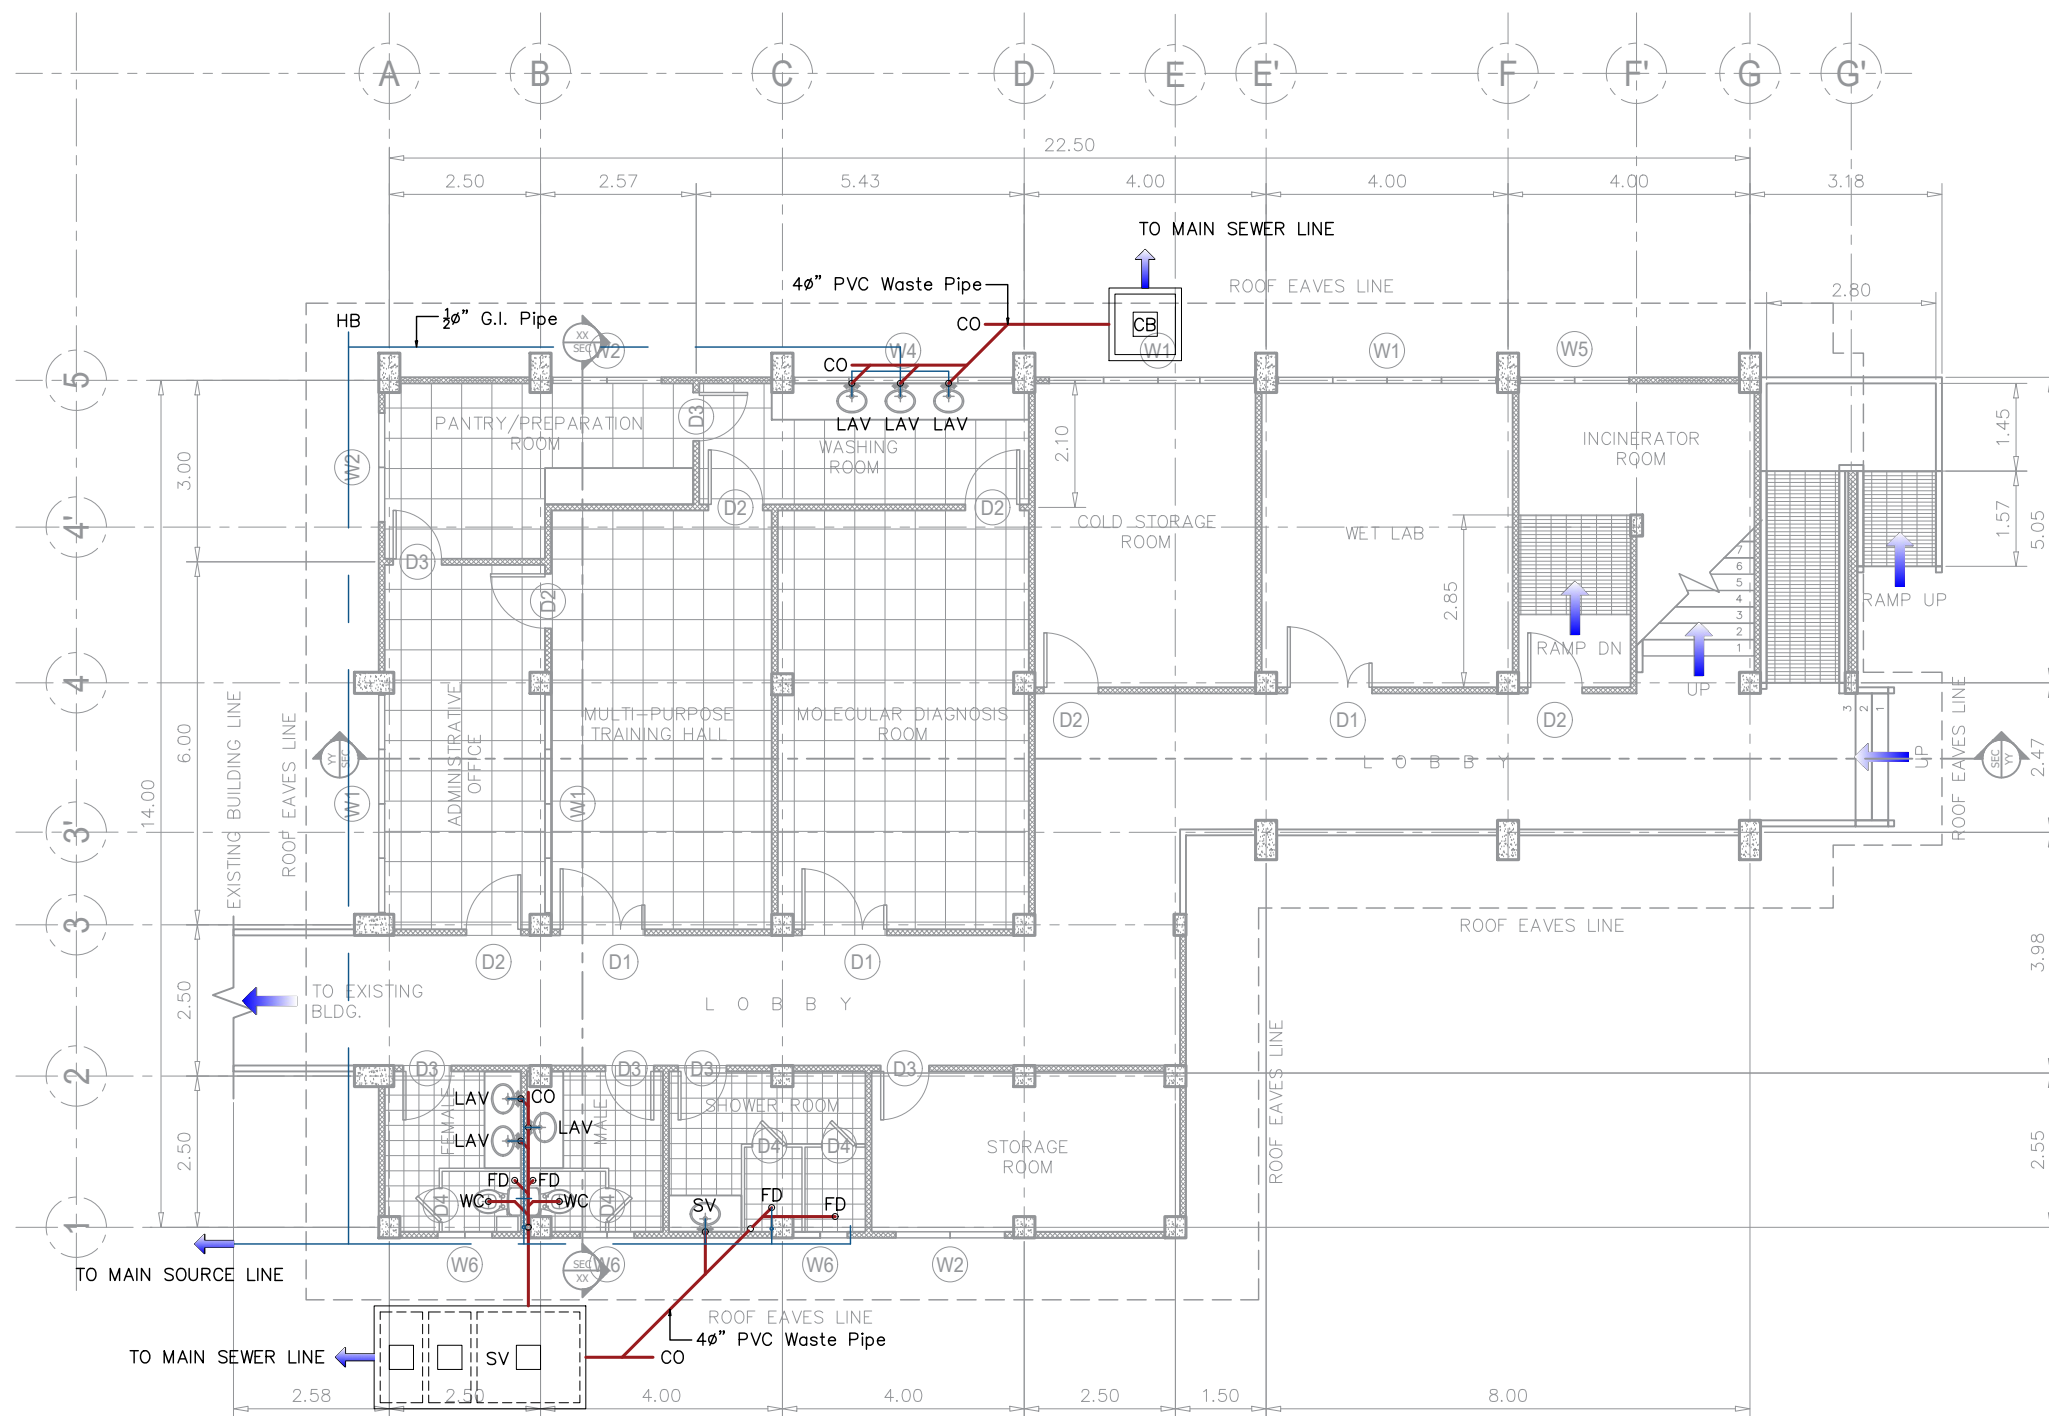

1 FIRST FLOOR PLUMBING LAYOUT
Scale: 1:125




TIN :	Approved by :	Project Title :	Checked by :	Noted by :	Conformed by :	Approved by :	Concept by :	P4 01 SHEET NO. 15 27
PRC :	Sanitary Engineer	CONSTRUCTION OF ANIMAL TESTING FACILITY	Engr. MARIO LILIO P. VALENZONA	Dr. SANTIAGO T. PENA, Jr.	Dr. DANIEL LESLIE S. TAN	Dr. EDGARDO E. TULIN	AutoCAD by :	
PTR :							Date Started :	
Date :							Date Finished :	
Place :							Place :	
		Location : VSU Main Campus, Baybay City, Leyte Philippines	DIRECTOR, PPO	DEAN, CVM	VP OF ADMINISTRATIVE AND FINANCE	VSU PRESIDENT		

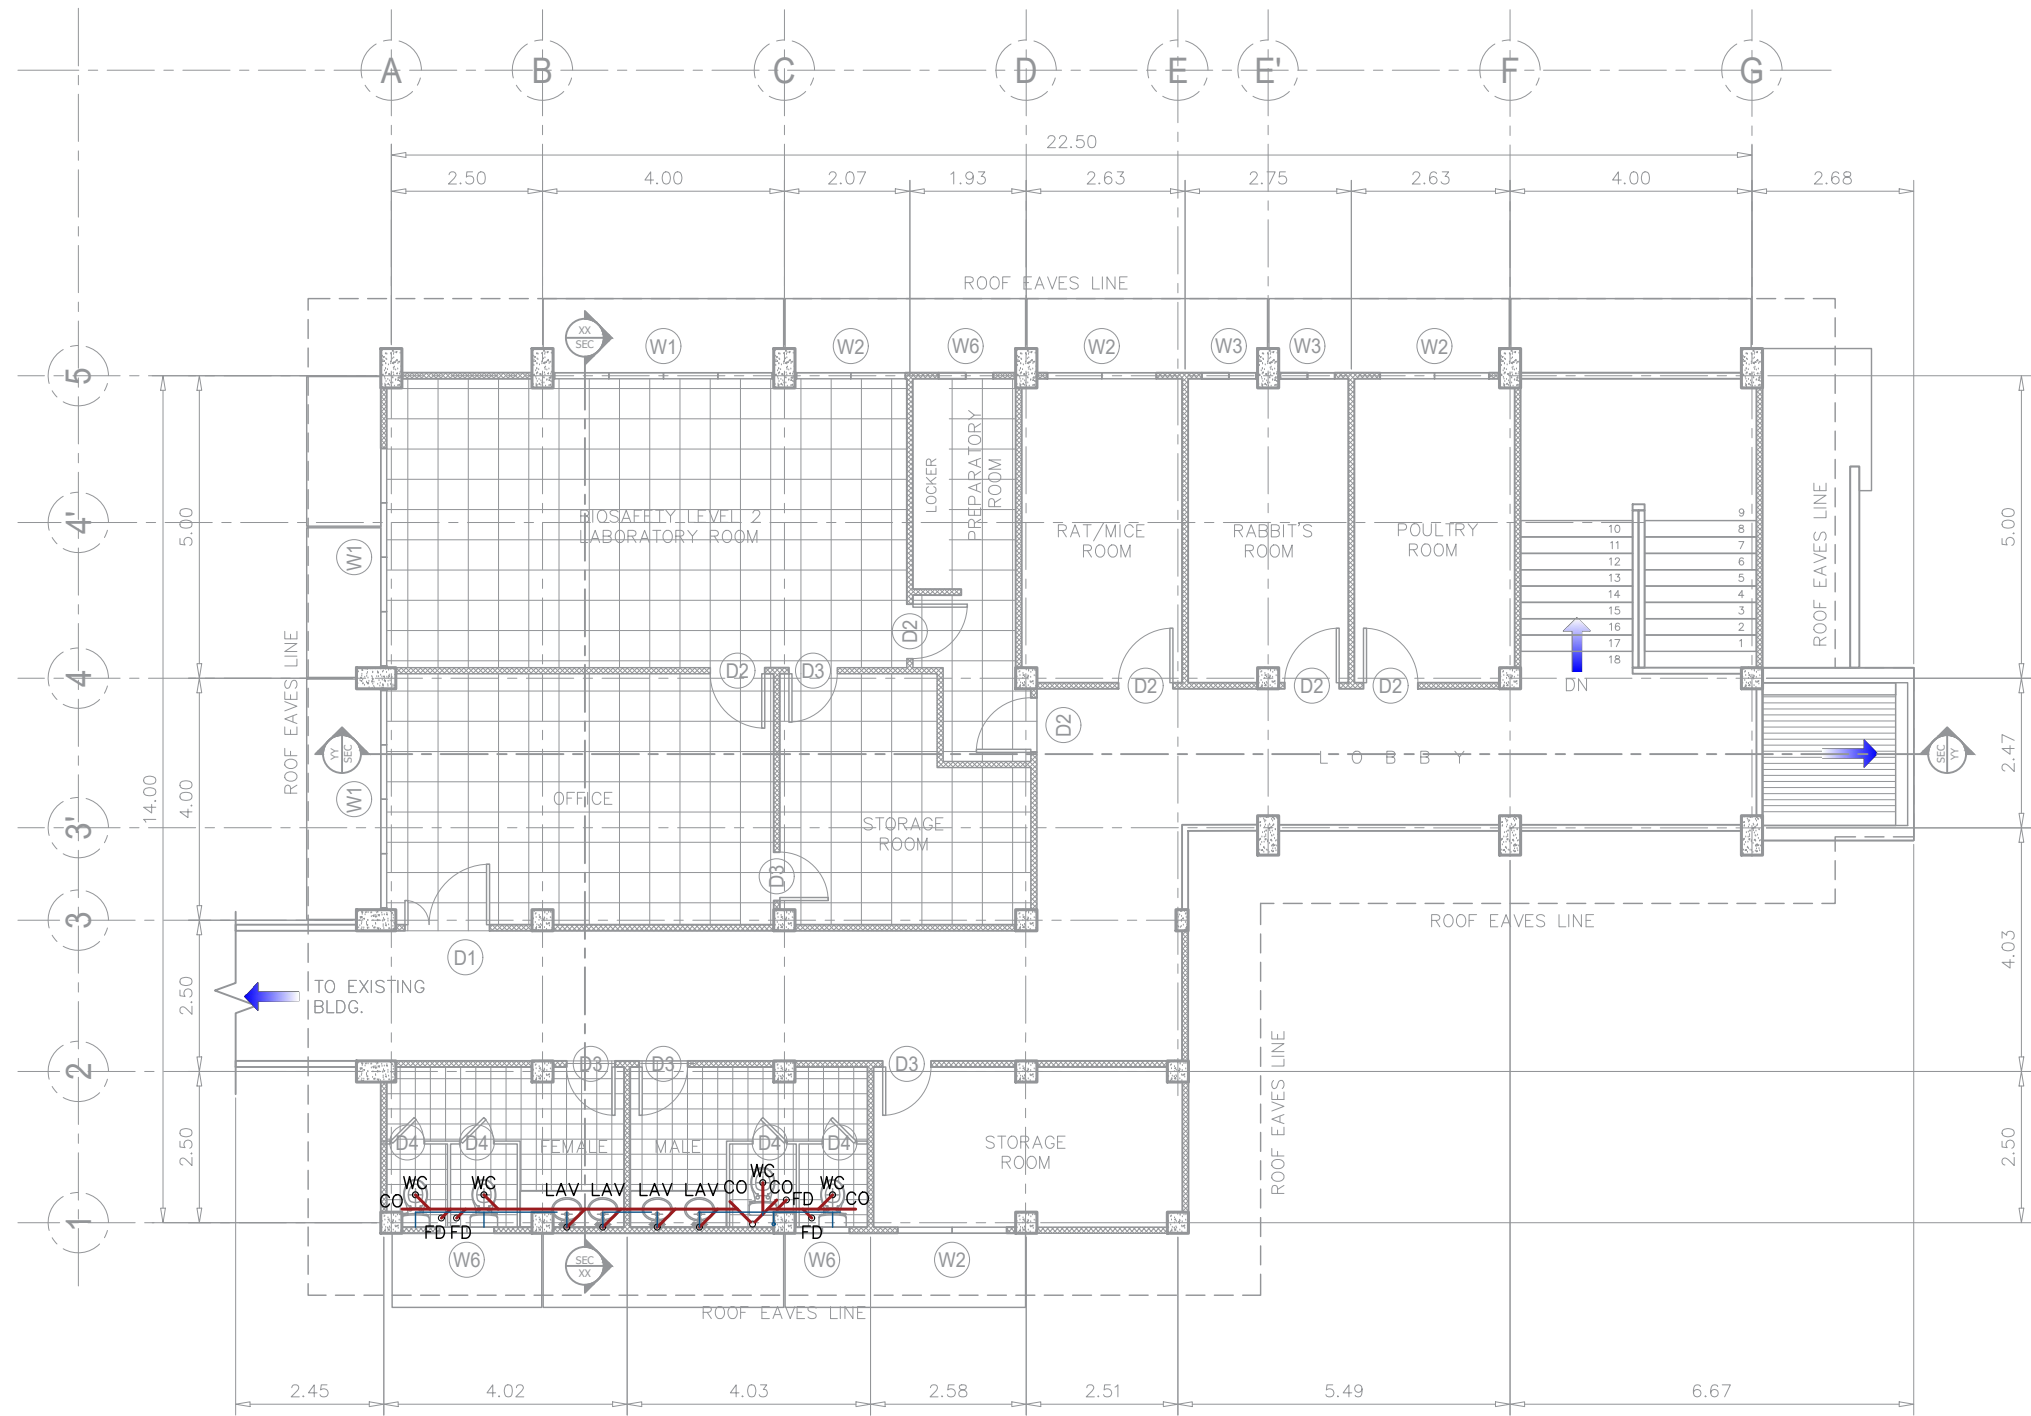

1 SECOND FLOOR PLUMBING LAYOUT
Scale: 1:125





TIN :	Approved by :	Project Title :	Checked by :	Noted by :	Conformed by :	Approved by :	Concept by :	P4 02
PRC :		CONSTRUCTION OF ANIMAL TESTING FACILITY	Engr. MARIO LILIO P. VALENZONA	Dr. SANTIAGO T. PENA, Jr.	Dr. DANIEL LESLIE S. TAN	Dr. EDGARDO E. TULIN	AutoCAD by :	SHEET NO.
PTR :		Location : VSU Main Campus, Baybay City, Leyte Philippines	DIRECTOR, PPO	DEAN, CVM	VP OF ADMINISTRATIVE AND FINANCE	VSU PRESIDENT	Date Started :	16 27
Date :							Date Finished :	
Place :	Sanitary Engineer						Place :	

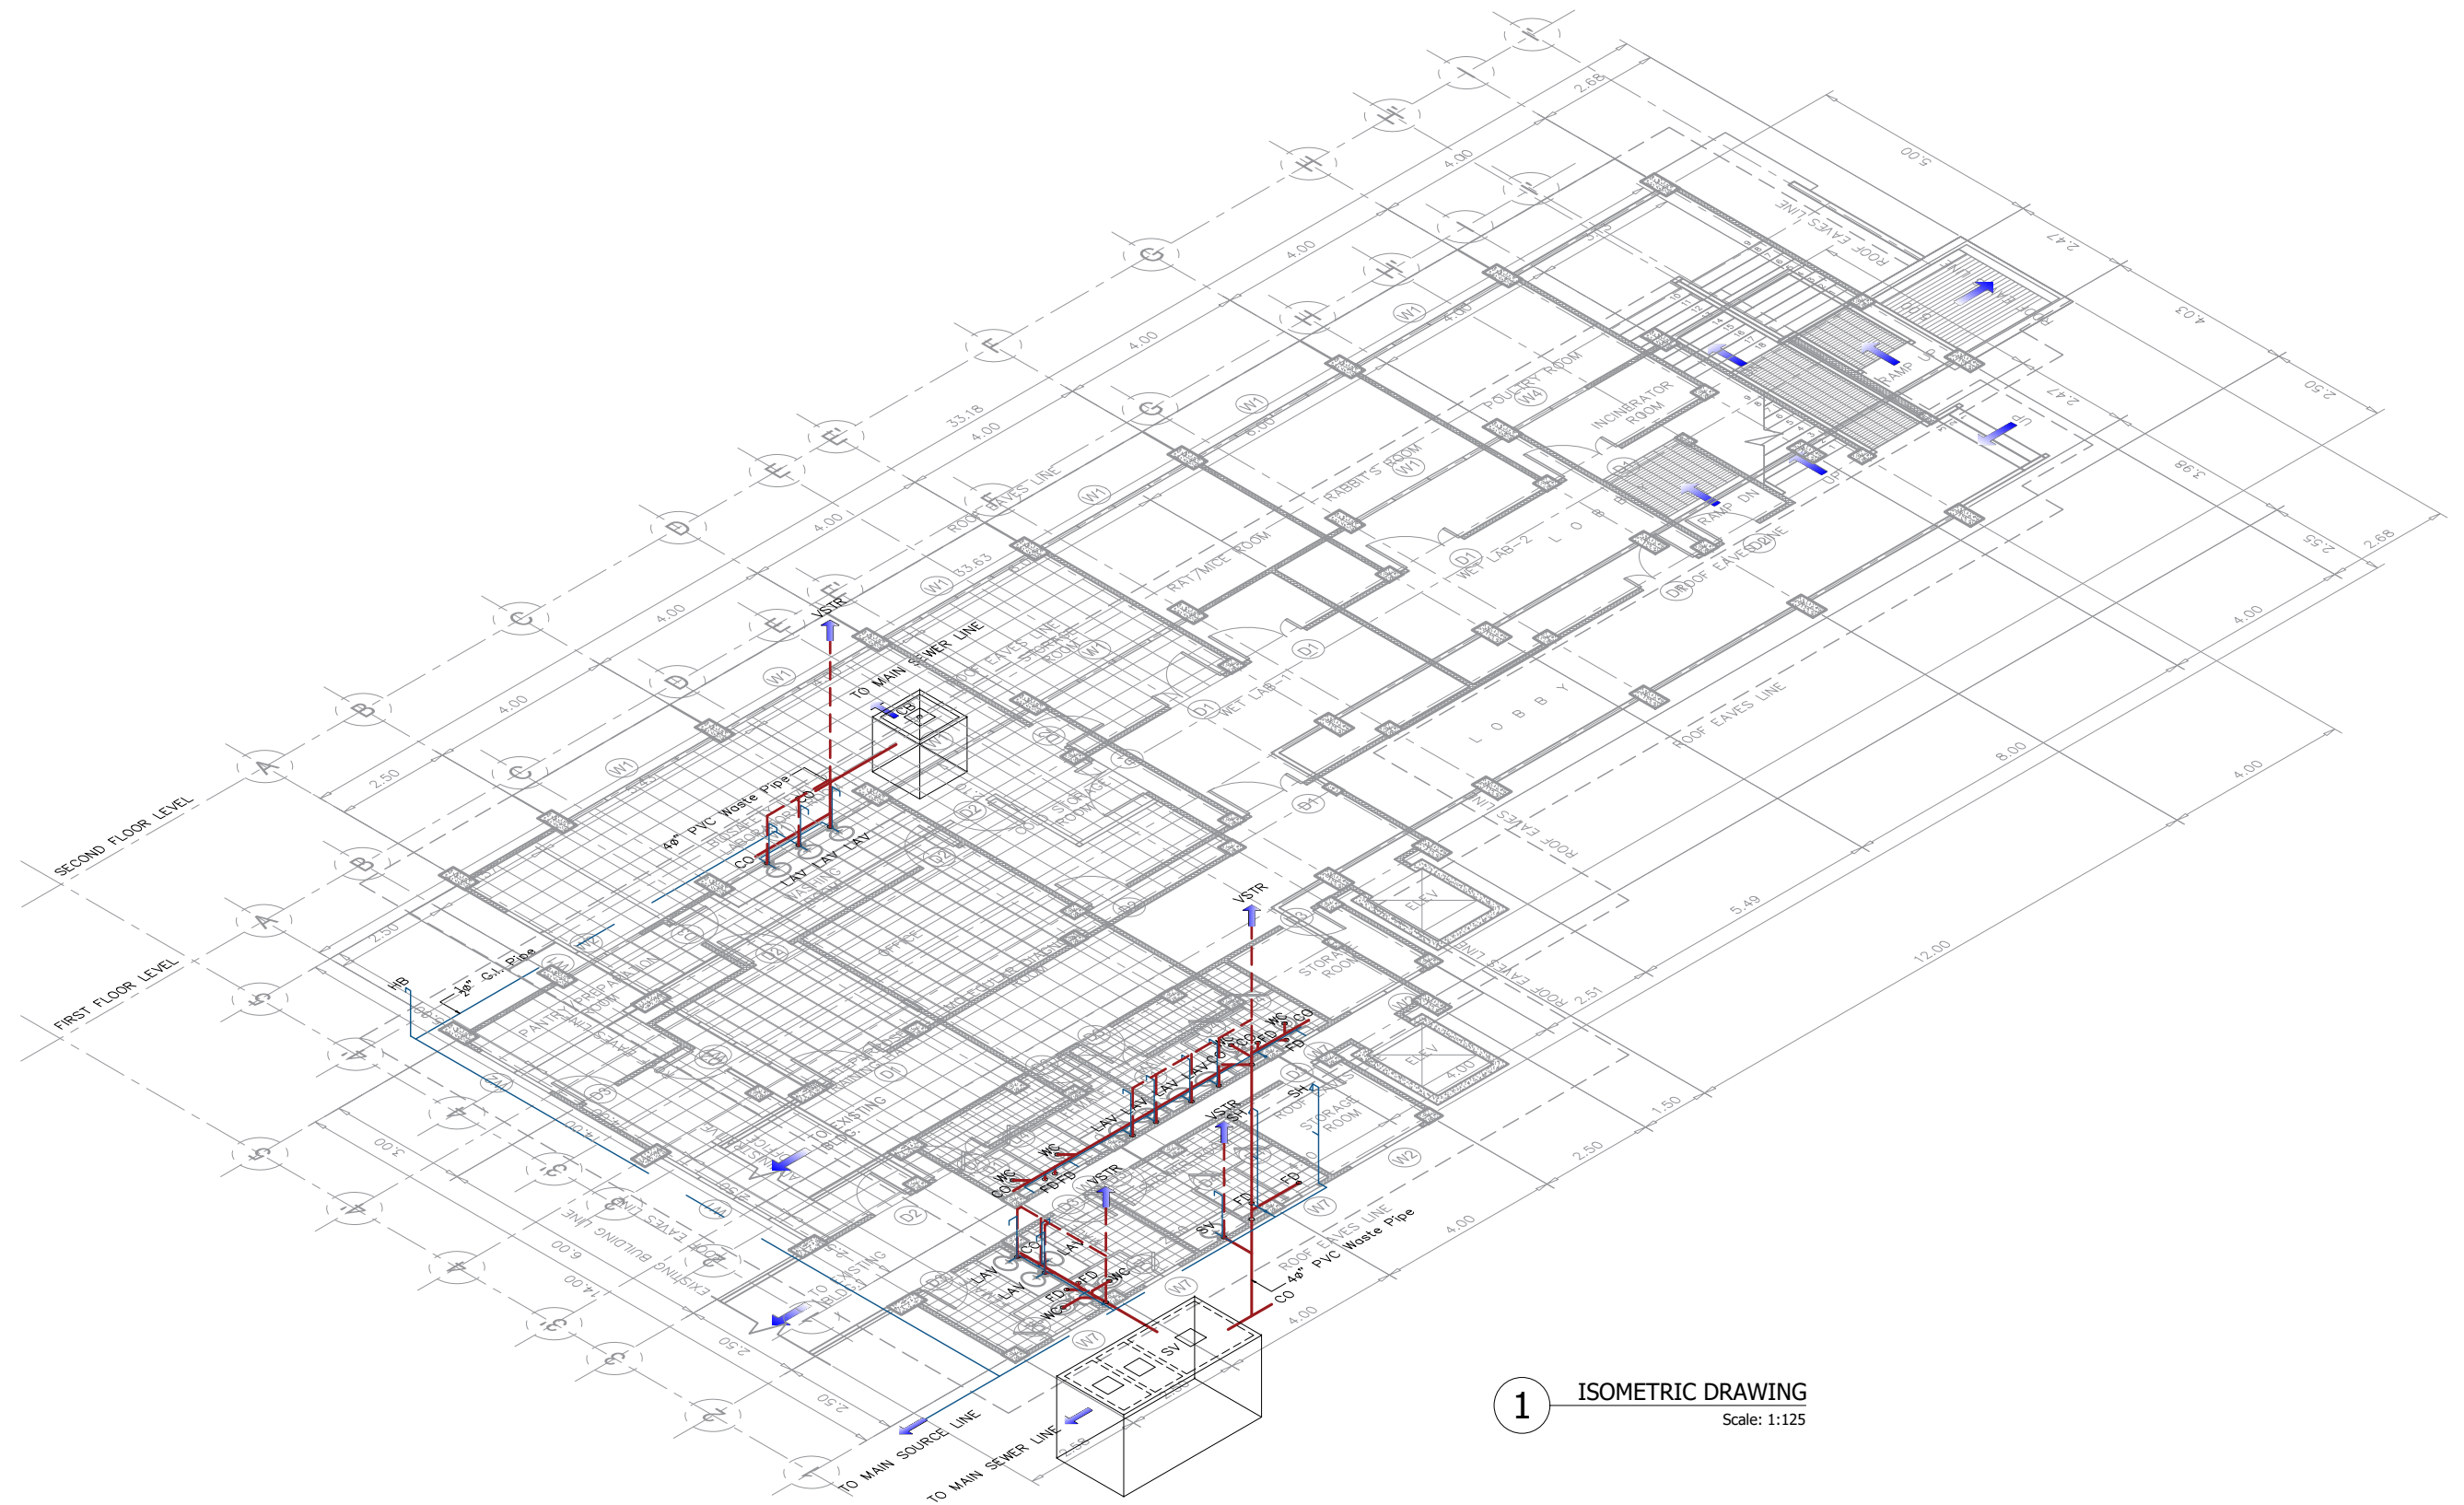


1 ISOMETRIC DRAWING
Scale: 1:125




TIN :	Approved by :	# 01 THIS DRAWING AND SPECIFICATIONS AND OTHER DOCUMENTS AND FIGURES FORMED BY THESE ARE INSTRUMENTS OF SERVICE. ANY AND ALL MODIFICATIONS AND ALTERATIONS TO ANY PART OF THESE DRAWINGS AND SPECIFICATIONS SHALL BE MADE ONLY BY THE ENGINEER OR ARCHITECT OR BY HIS AUTHORIZED REPRESENTATIVE. ANY AND ALL MODIFICATIONS SHALL BE MADE IN WRITING AND SHALL BE SIGNED BY THE ENGINEER OR ARCHITECT OR BY HIS AUTHORIZED REPRESENTATIVE. ANY AND ALL MODIFICATIONS SHALL BE MADE IN WRITING AND SHALL BE SIGNED BY THE ENGINEER OR ARCHITECT OR BY HIS AUTHORIZED REPRESENTATIVE.	Project Title :	Checked by :	Noted by :	Conformed by :	Approved by :	Concept by :	P403 SHEET NO. 1727	
PRC :			CONSTRUCTION OF ANIMAL TESTING FACILITY	Engr. MARIO LILIO P. VALENZONA	Dr. SANTIAGO T. PENA, Jr.	Dr. DANIEL LESLIE S. TAN	Dr. DANIEL LESLIE S. TAN	Dr. EDGARDO E. TULIN		AutoCAD by :
PTR :										Date Started :
Date :										Date Finished :
Place :	Sanitary Engineer									Location : VSU Main Campus, Baybay City, Leyte Philippines

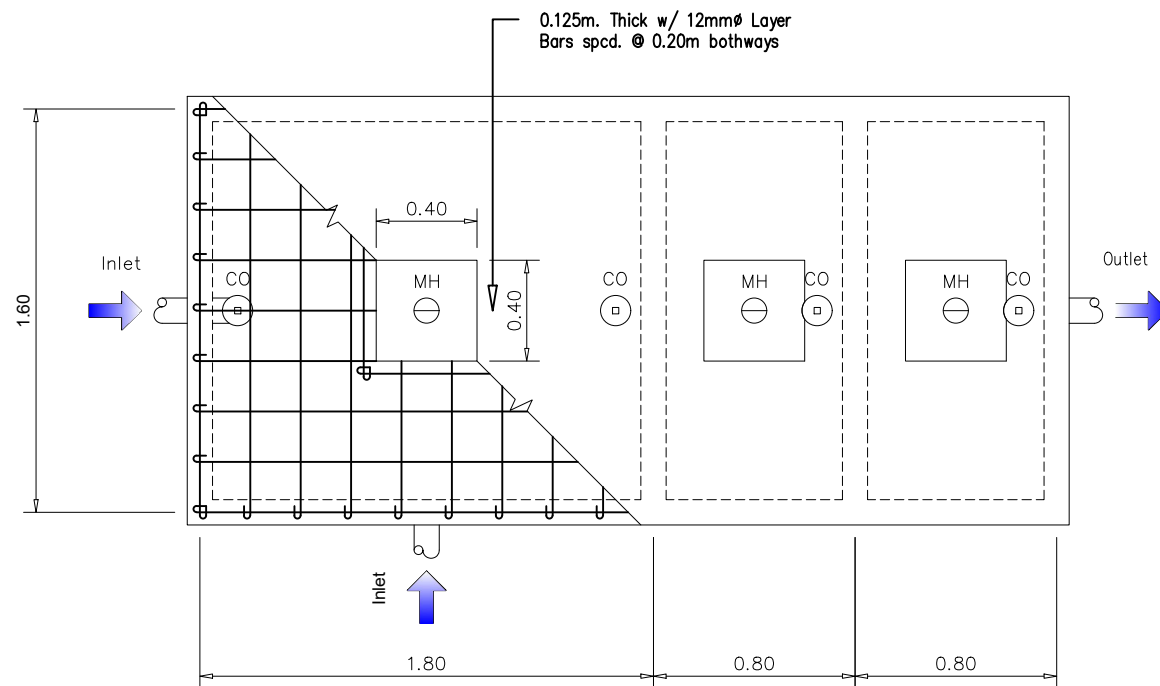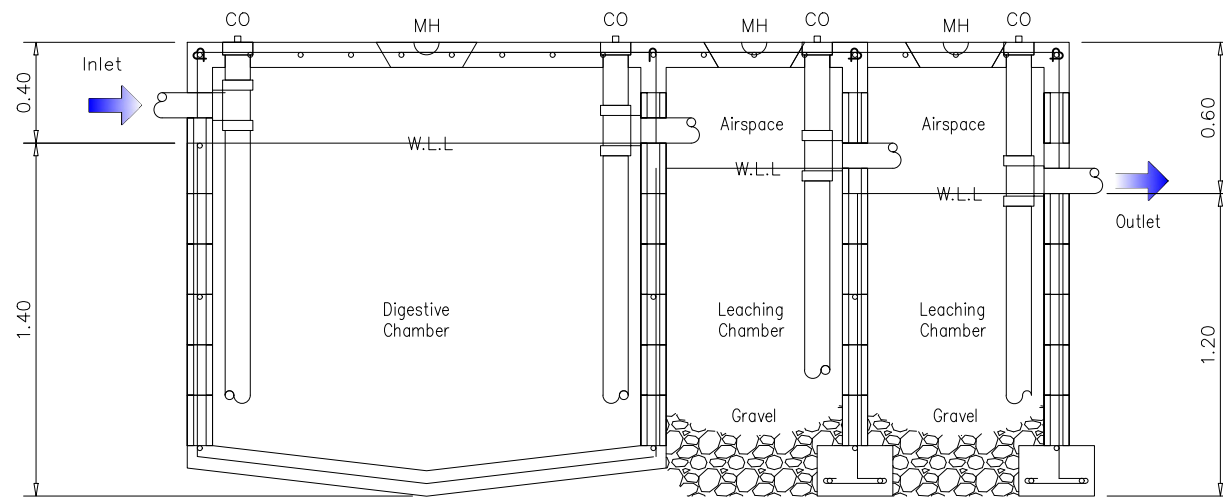

1 **DETAIL OF R.C. SEPTIC VAULT**
Scale: 1:125

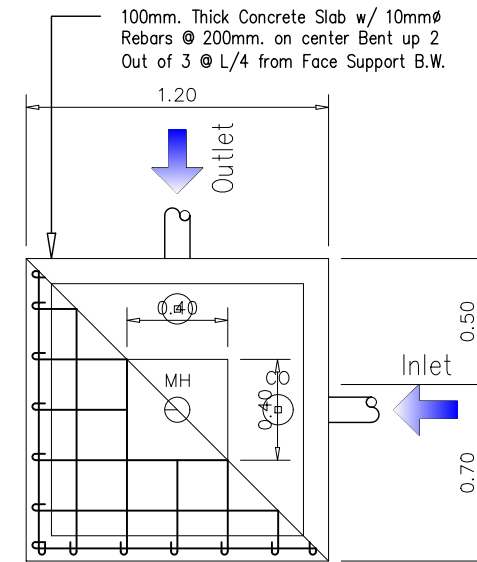

2 **DETAIL OF R.C. CATCH BASIN**
Scale: 1:125

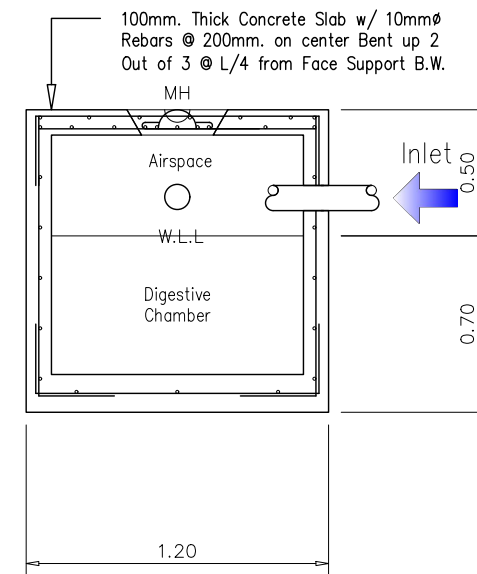

3 **PLUMBING NOTE**

- ALL WORKS SHALL CONFORM TO THE RULES AND REGULATION OF THE NATIONAL PLUMBING CODE.
- PLUMBING INSTALLATIONS SHALL BE DONE THRU THE DIRECT SUPERVISION OF A DULY LICENSED MASTER PLUMBER.
- ALL MATERIALS TO BE USED SHALL BE NEW AND APPROVED TYPE OF LOCATION AND PURPOSE.
- RUN ALL HORIZONTAL PIPINGS IN PERFECT ALIGNMENT AND AT A FORM GRADE NOT LESS THAN TWO PERCENT (2%).
- THE DIGESTION CHAMBER OF SEPTIC TANK MUST BE WATERPROOFED.
- NO SEPTIC TANK SHALL BE CONSTRUCTED UNDER THE BUILDING.
- NOT LESS THAN 300MM. OF AIR SPACE MUST BE LEFT BETWEEN THE TOP OF THE SEWAGE AND THE UNDER PART OF TANK ROOF SLAB.
- ALL PLUMBING WORKS SHALL BE UNDER THE DIRECT SUPERVISION OF A LICENSED MASTER PLUMBER AND ARCHITECT.

4 **LEGEND**

- CV CHECK VALVE
- F FAUCET
- FD FLOOR DRAIN
- CB CATCH BASIN
- CS COUNTER SINK
- GV GATE VALVE
- HB HOSE BIBB
- LAV LAVATORY
- MH MANHOLE
- SH SHOWER HEAD
- SV SEPTIC VAULT
- VSTR VENT STACH THRU ROOF
- WC WATER CLOSET
- WM WATER METER
- 2"Ø PVC VENT PIPE LINE
- 4"Ø PVC WASTE PIPE LINE
- 1/2"Ø PVC WATER PIPE LINE